



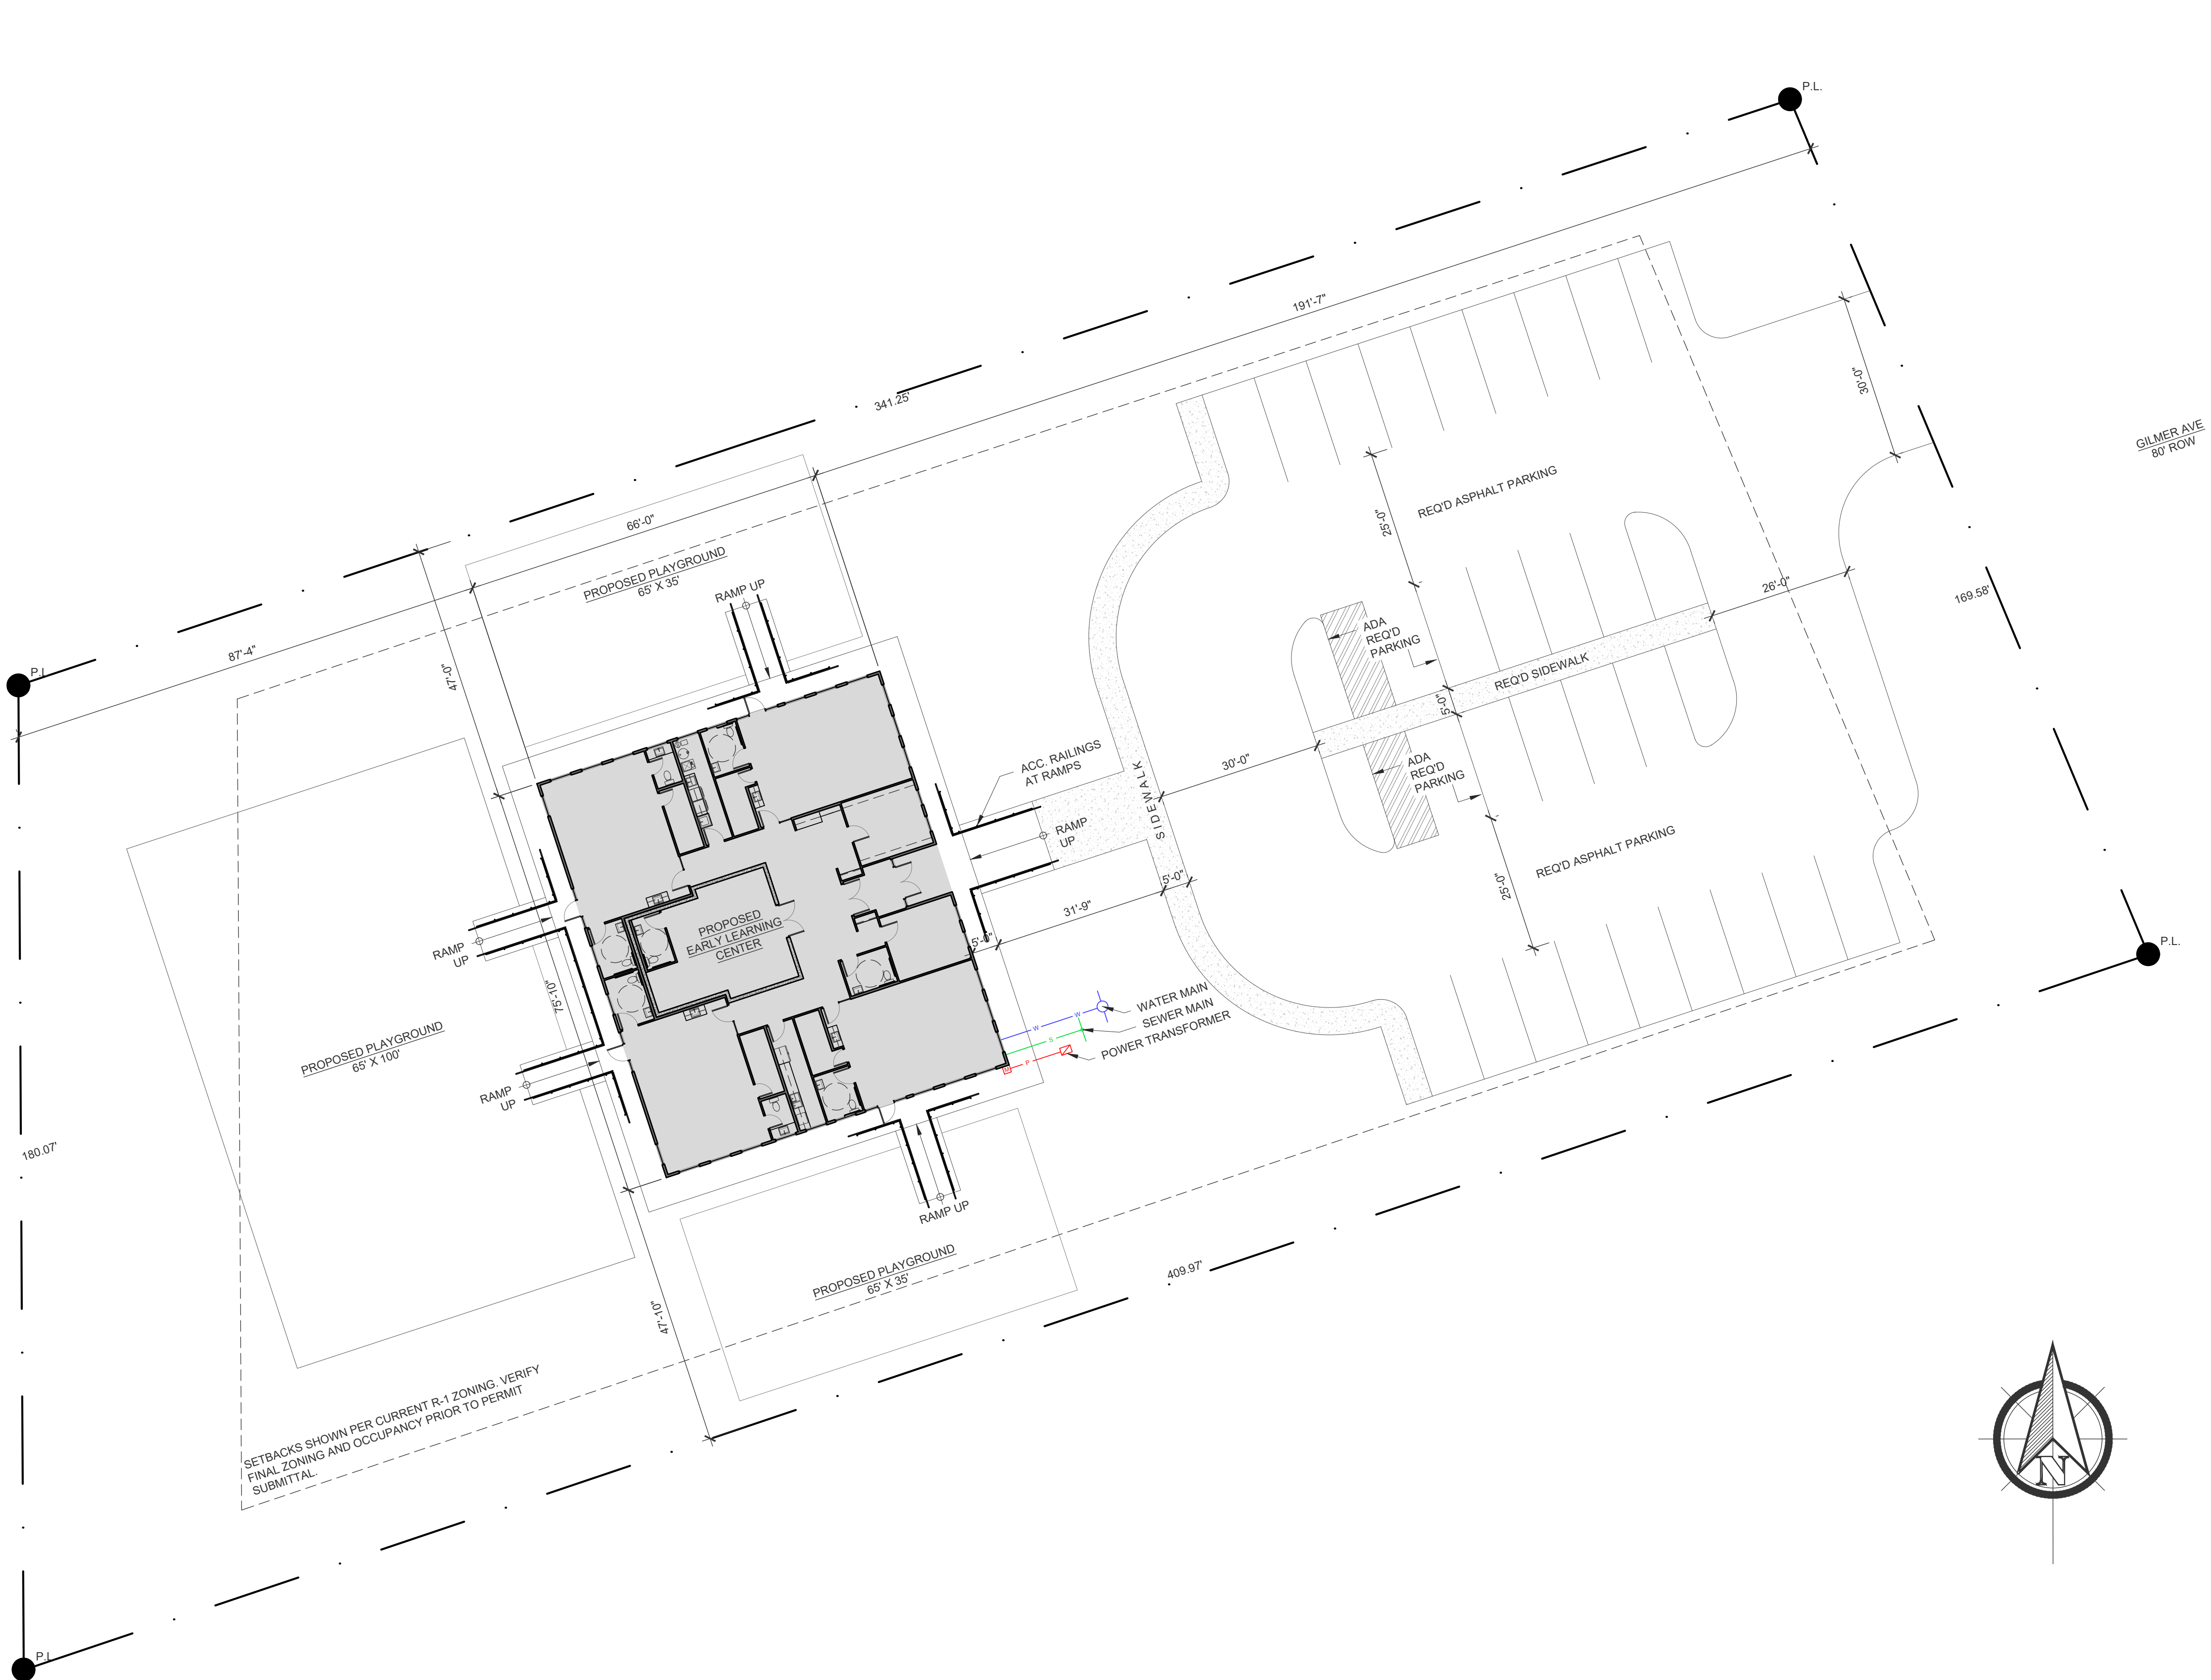

SETBACKS SHOWN PER CURRENT R-1 ZONING. VERIFY
FINAL ZONING AND OCCUPANCY PRIOR TO PERMIT
SUBMITTAL.

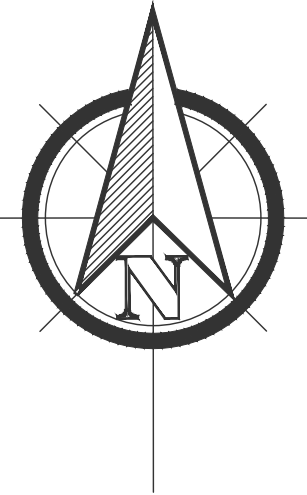



GENERAL NOTES


- 2X6 EXTERIOR FRAMING.
2X4 INTERIOR FRAMING UNLESS NOTED
OTHERWISE ON PLAN.
- 9'-1" WALL HEIGHT THROUGHOUT UNLESS NOTED
OTHERWISE ON PLAN.
- 7'-0" WINDOW HEADER HEIGHT,
& 7'-0" TALL INTERIOR & EXTERIOR DOORS
UNLESS NOTED OTHERWISE ON PLAN.
- ENSURE THAT ALL OPENINGS PASSING THROUGH
FIREWALLS AND ROOF SURFACES ARE PROPERLY
SEALED WITH FLASHING AND CAULKING.
- REFER TO THE STRUCTURAL DRAWINGS TO
DETERMINE THE SIZE AND PLACEMENT OF ALL
STRUCTURAL COMPONENTS

BUILDING AREAS

CLASSROOM 1:	761 S.F.
CLASSROOM 2:	761 S.F.
STORM SHELTER:	588 S.F.
KITCHEN:	109 S.F.
HALLWAYS:	413 S.F.
UTILITY:	109 S.F.
CLASSROOM 3:	722 S.F.
CLASSROOM 4:	722 S.F.
ADA ACC. RESTROOM:	64 S.F.
RECEPTION:	73 S.F.
OFFICE 1:	211 S.F.
OFFICE 2:	241 S.F.
ENTRY:	229 S.F.
TOTAL AREA:	5,003 S.F.

FLOOR LAYOUT PLAN

SCALE: 1/4" = 1'-0"

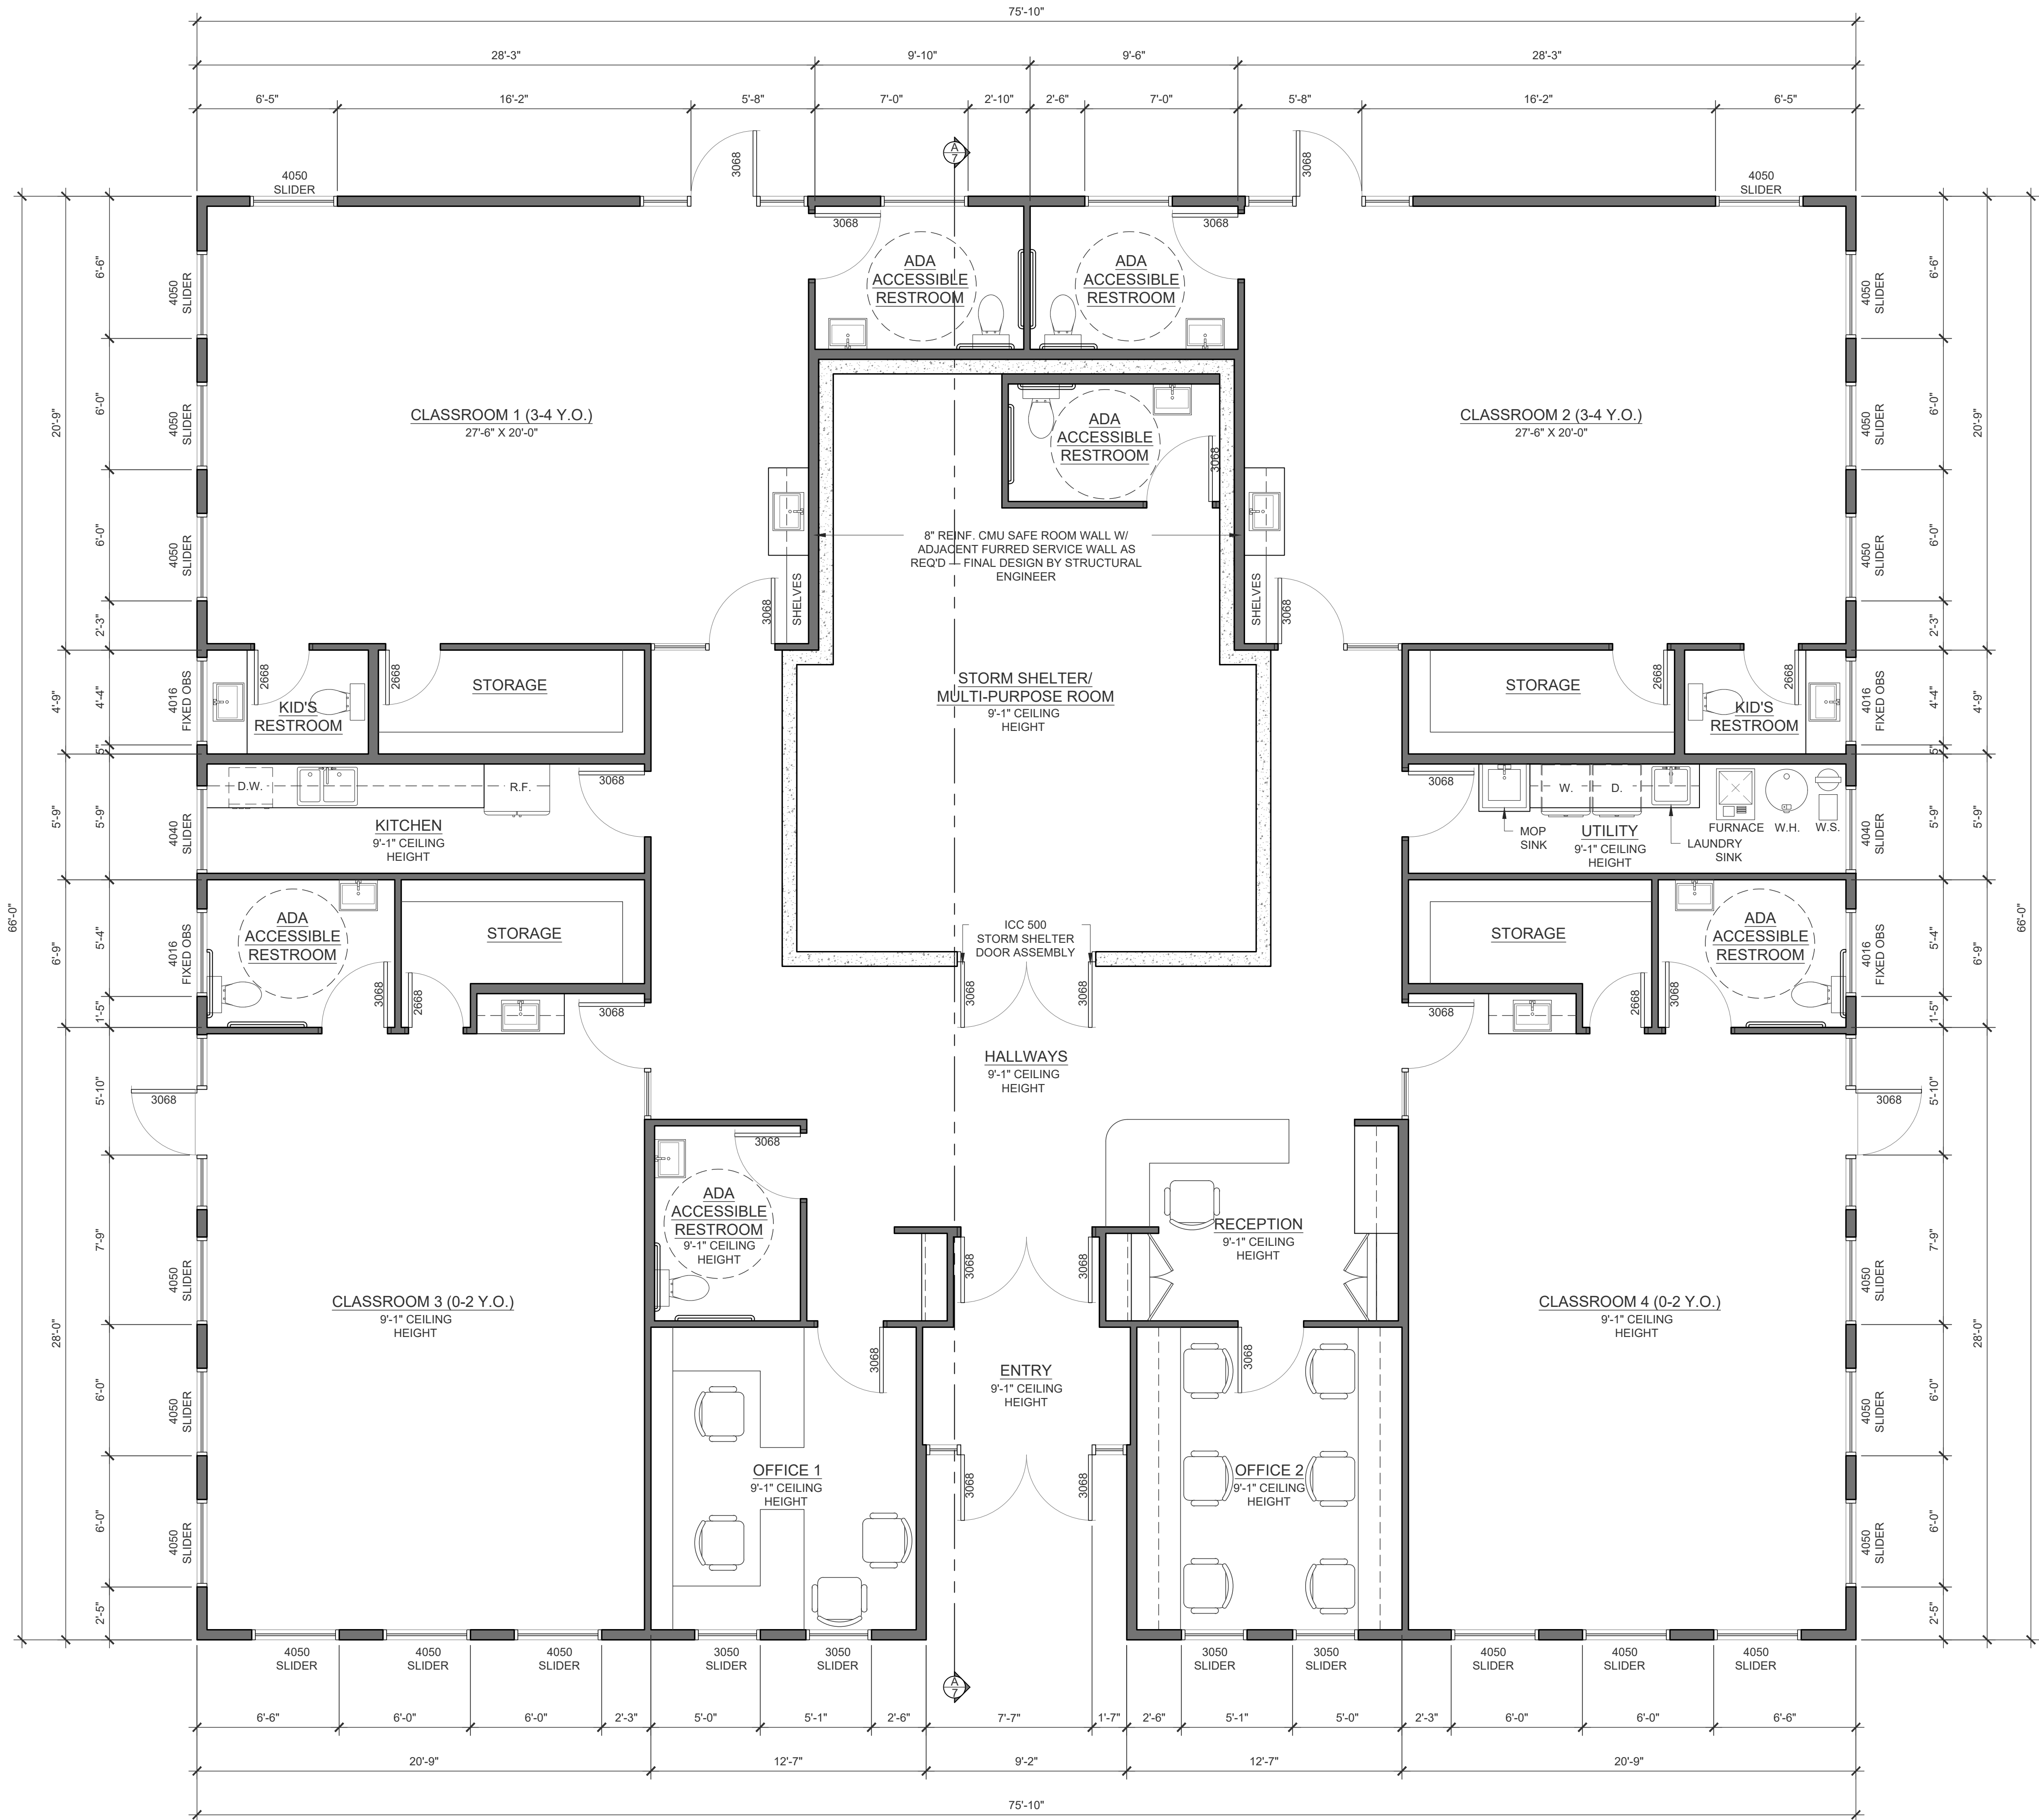

FLOOR DIMENSION PLAN


SCALE: 1/4" = 1'-0"

GENERAL NOTES

- 2X6 EXTERIOR FRAMING.
2X4 INTERIOR FRAMING UNLESS NOTED OTHERWISE ON PLAN.
- 9'-1" WALL HEIGHT THROUGHOUT UNLESS NOTED OTHERWISE ON PLAN.
- 7'-0" WINDOW HEADER HEIGHT,
& 7'-0" TALL INTERIOR & EXTERIOR DOORS UNLESS NOTED OTHERWISE ON PLAN.
- ENSURE THAT ALL OPENINGS PASSING THROUGH FIREWALLS AND ROOF SURFACES ARE PROPERLY SEALED WITH FLASHING AND CAULKING.
- REFER TO THE STRUCTURAL DRAWINGS TO DETERMINE THE SIZE AND PLACEMENT OF ALL STRUCTURAL COMPONENTS

BUILDING AREAS

CLASSROOM 1:	761 S.F.
CLASSROOM 2:	761 S.F.
STORM SHELTER:	588 S.F.
KITCHEN:	109 S.F.
HALLWAYS:	413 S.F.
UTILITY:	109 S.F.
CLASSROOM 3:	722 S.F.
CLASSROOM 4:	722 S.F.
ADA ACC. RESTROOM:	64 S.F.
RECEPTION:	73 S.F.
OFFICE 1:	211 S.F.
OFFICE 2:	241 S.F.
ENTRY:	229 S.F.
TOTAL AREA:	5,003 S.F.

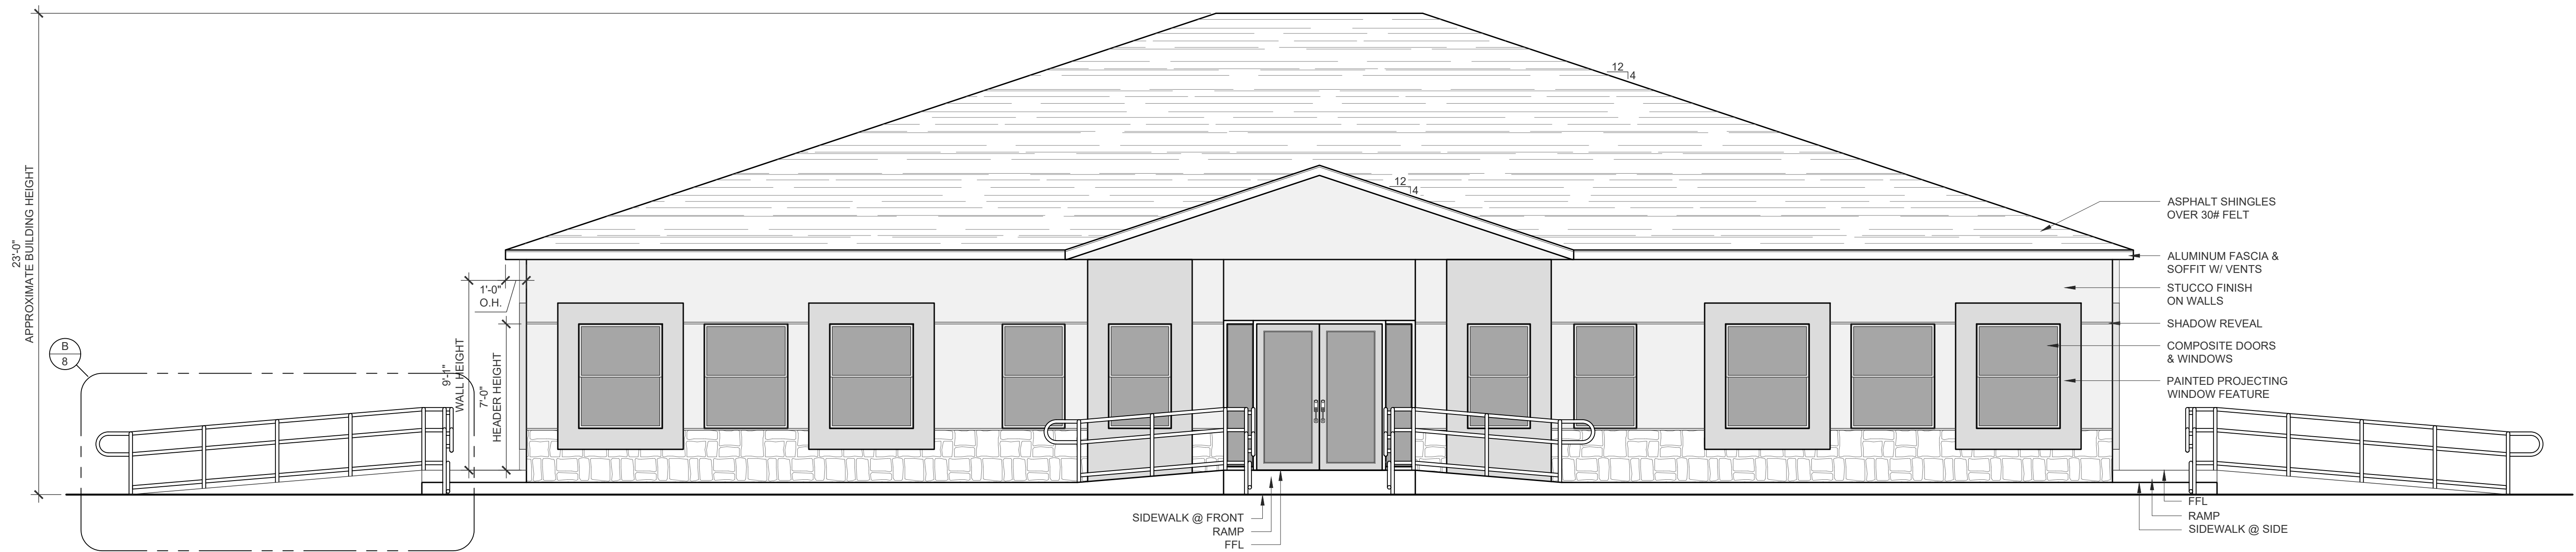


FRONT ELEVATION

SCALE: 1/4" = 1'-0"



RIGHT ELEVATION

SCALE: 1/4" = 1'-0"

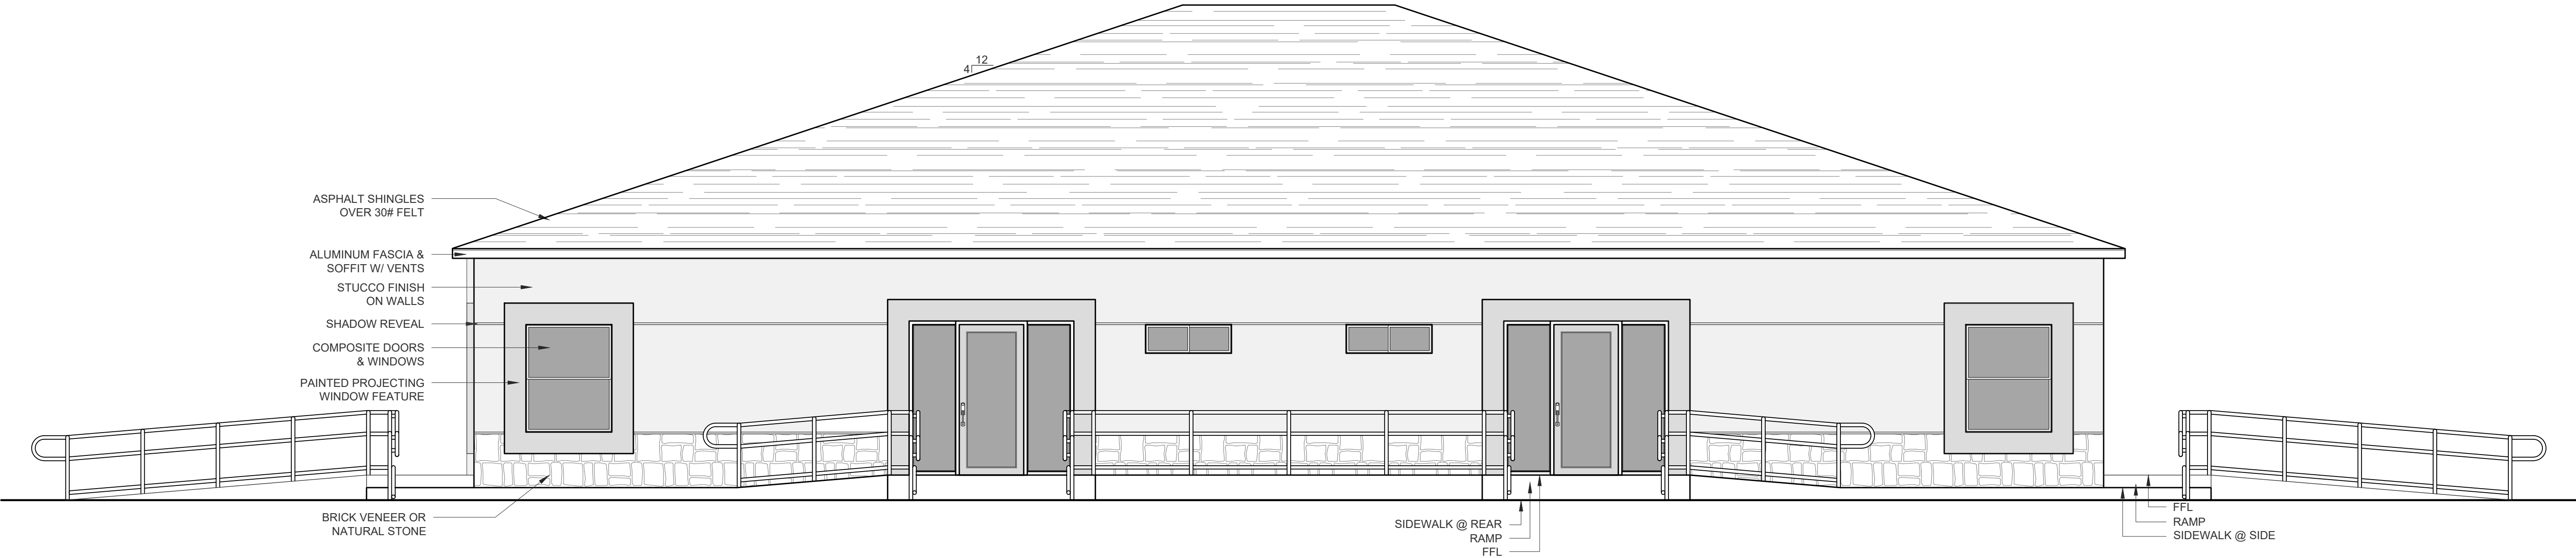



REAR ELEVATION

SCALE: 1/4" = 1'-0"




LEFT ELEVATION

SCALE: 1/4" = 1'-0"

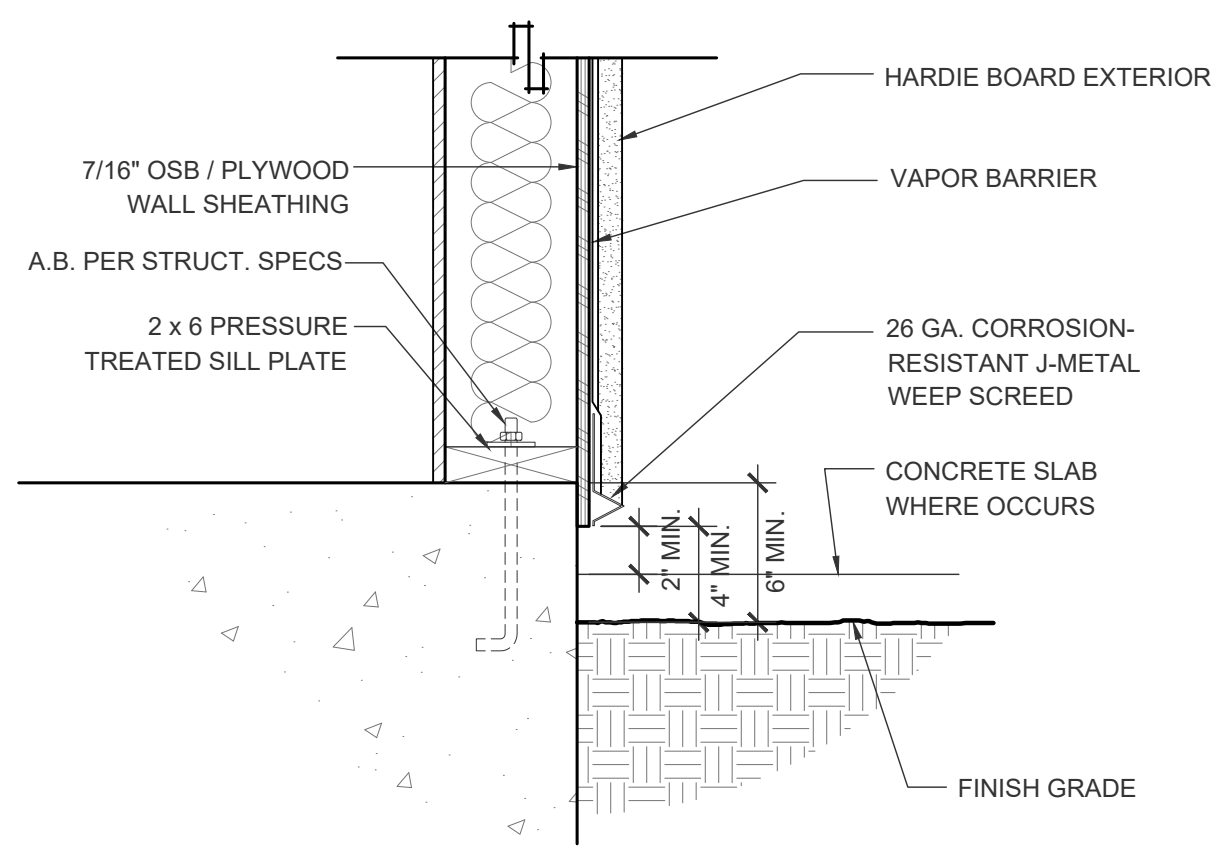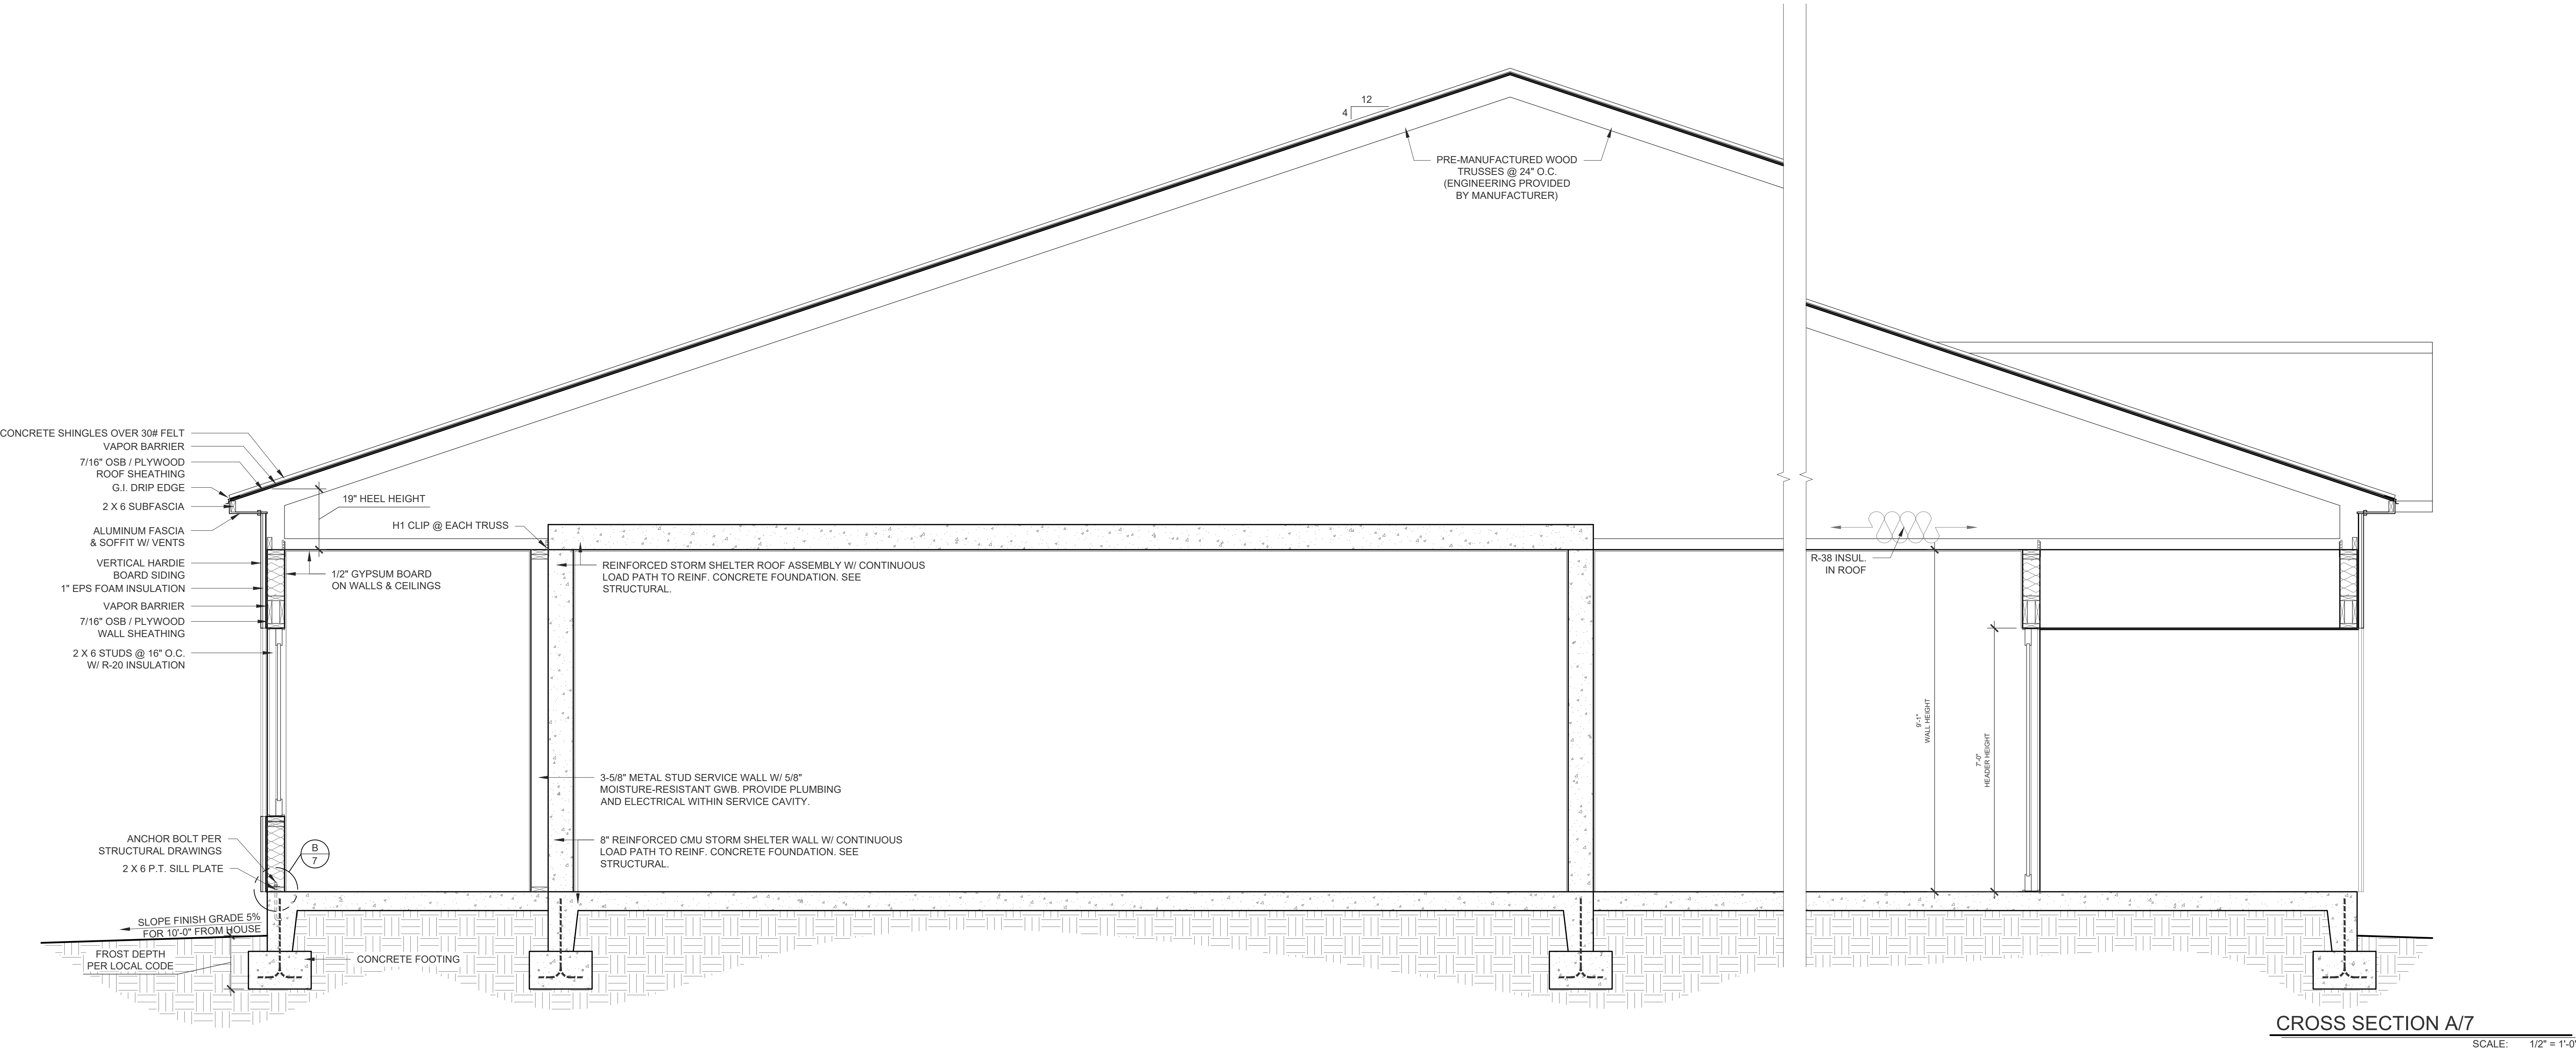


WEEP SCREED DETAIL B/7
SCALE: 1/2" = 1'-0"

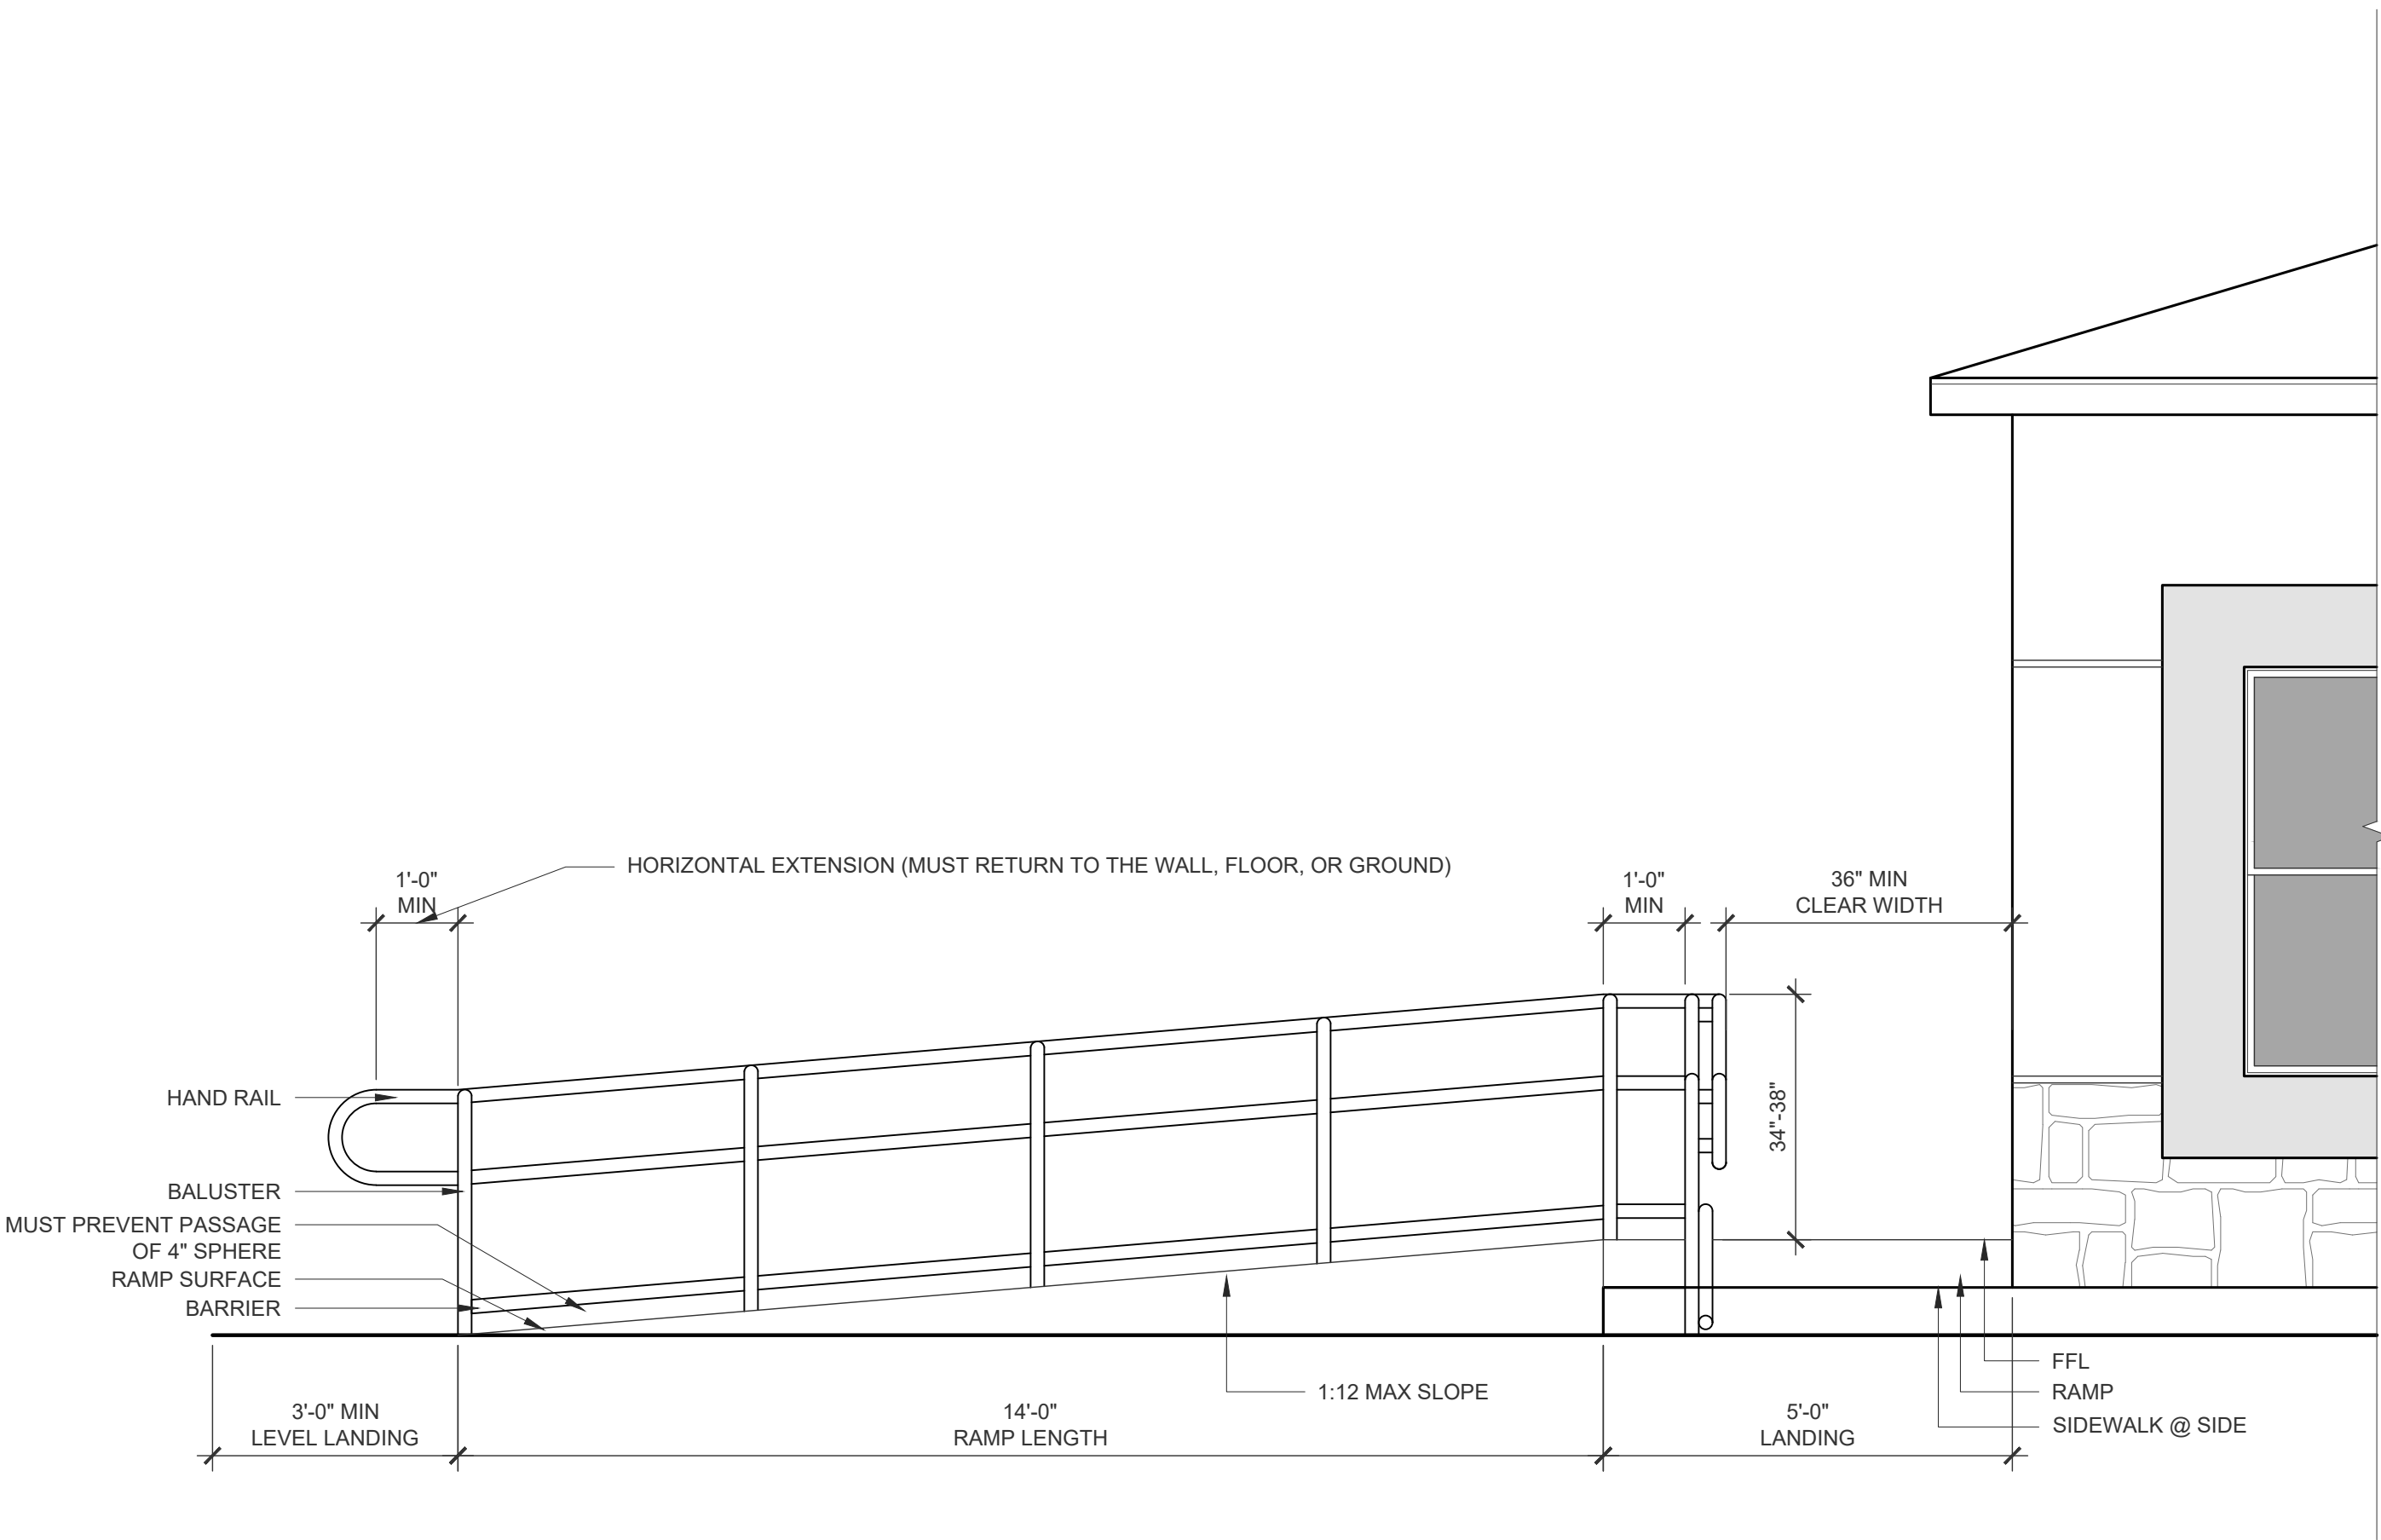

ACCESSIBLE RAMP DETAILS A/8

SCALE: 1/2" = 1'-0"

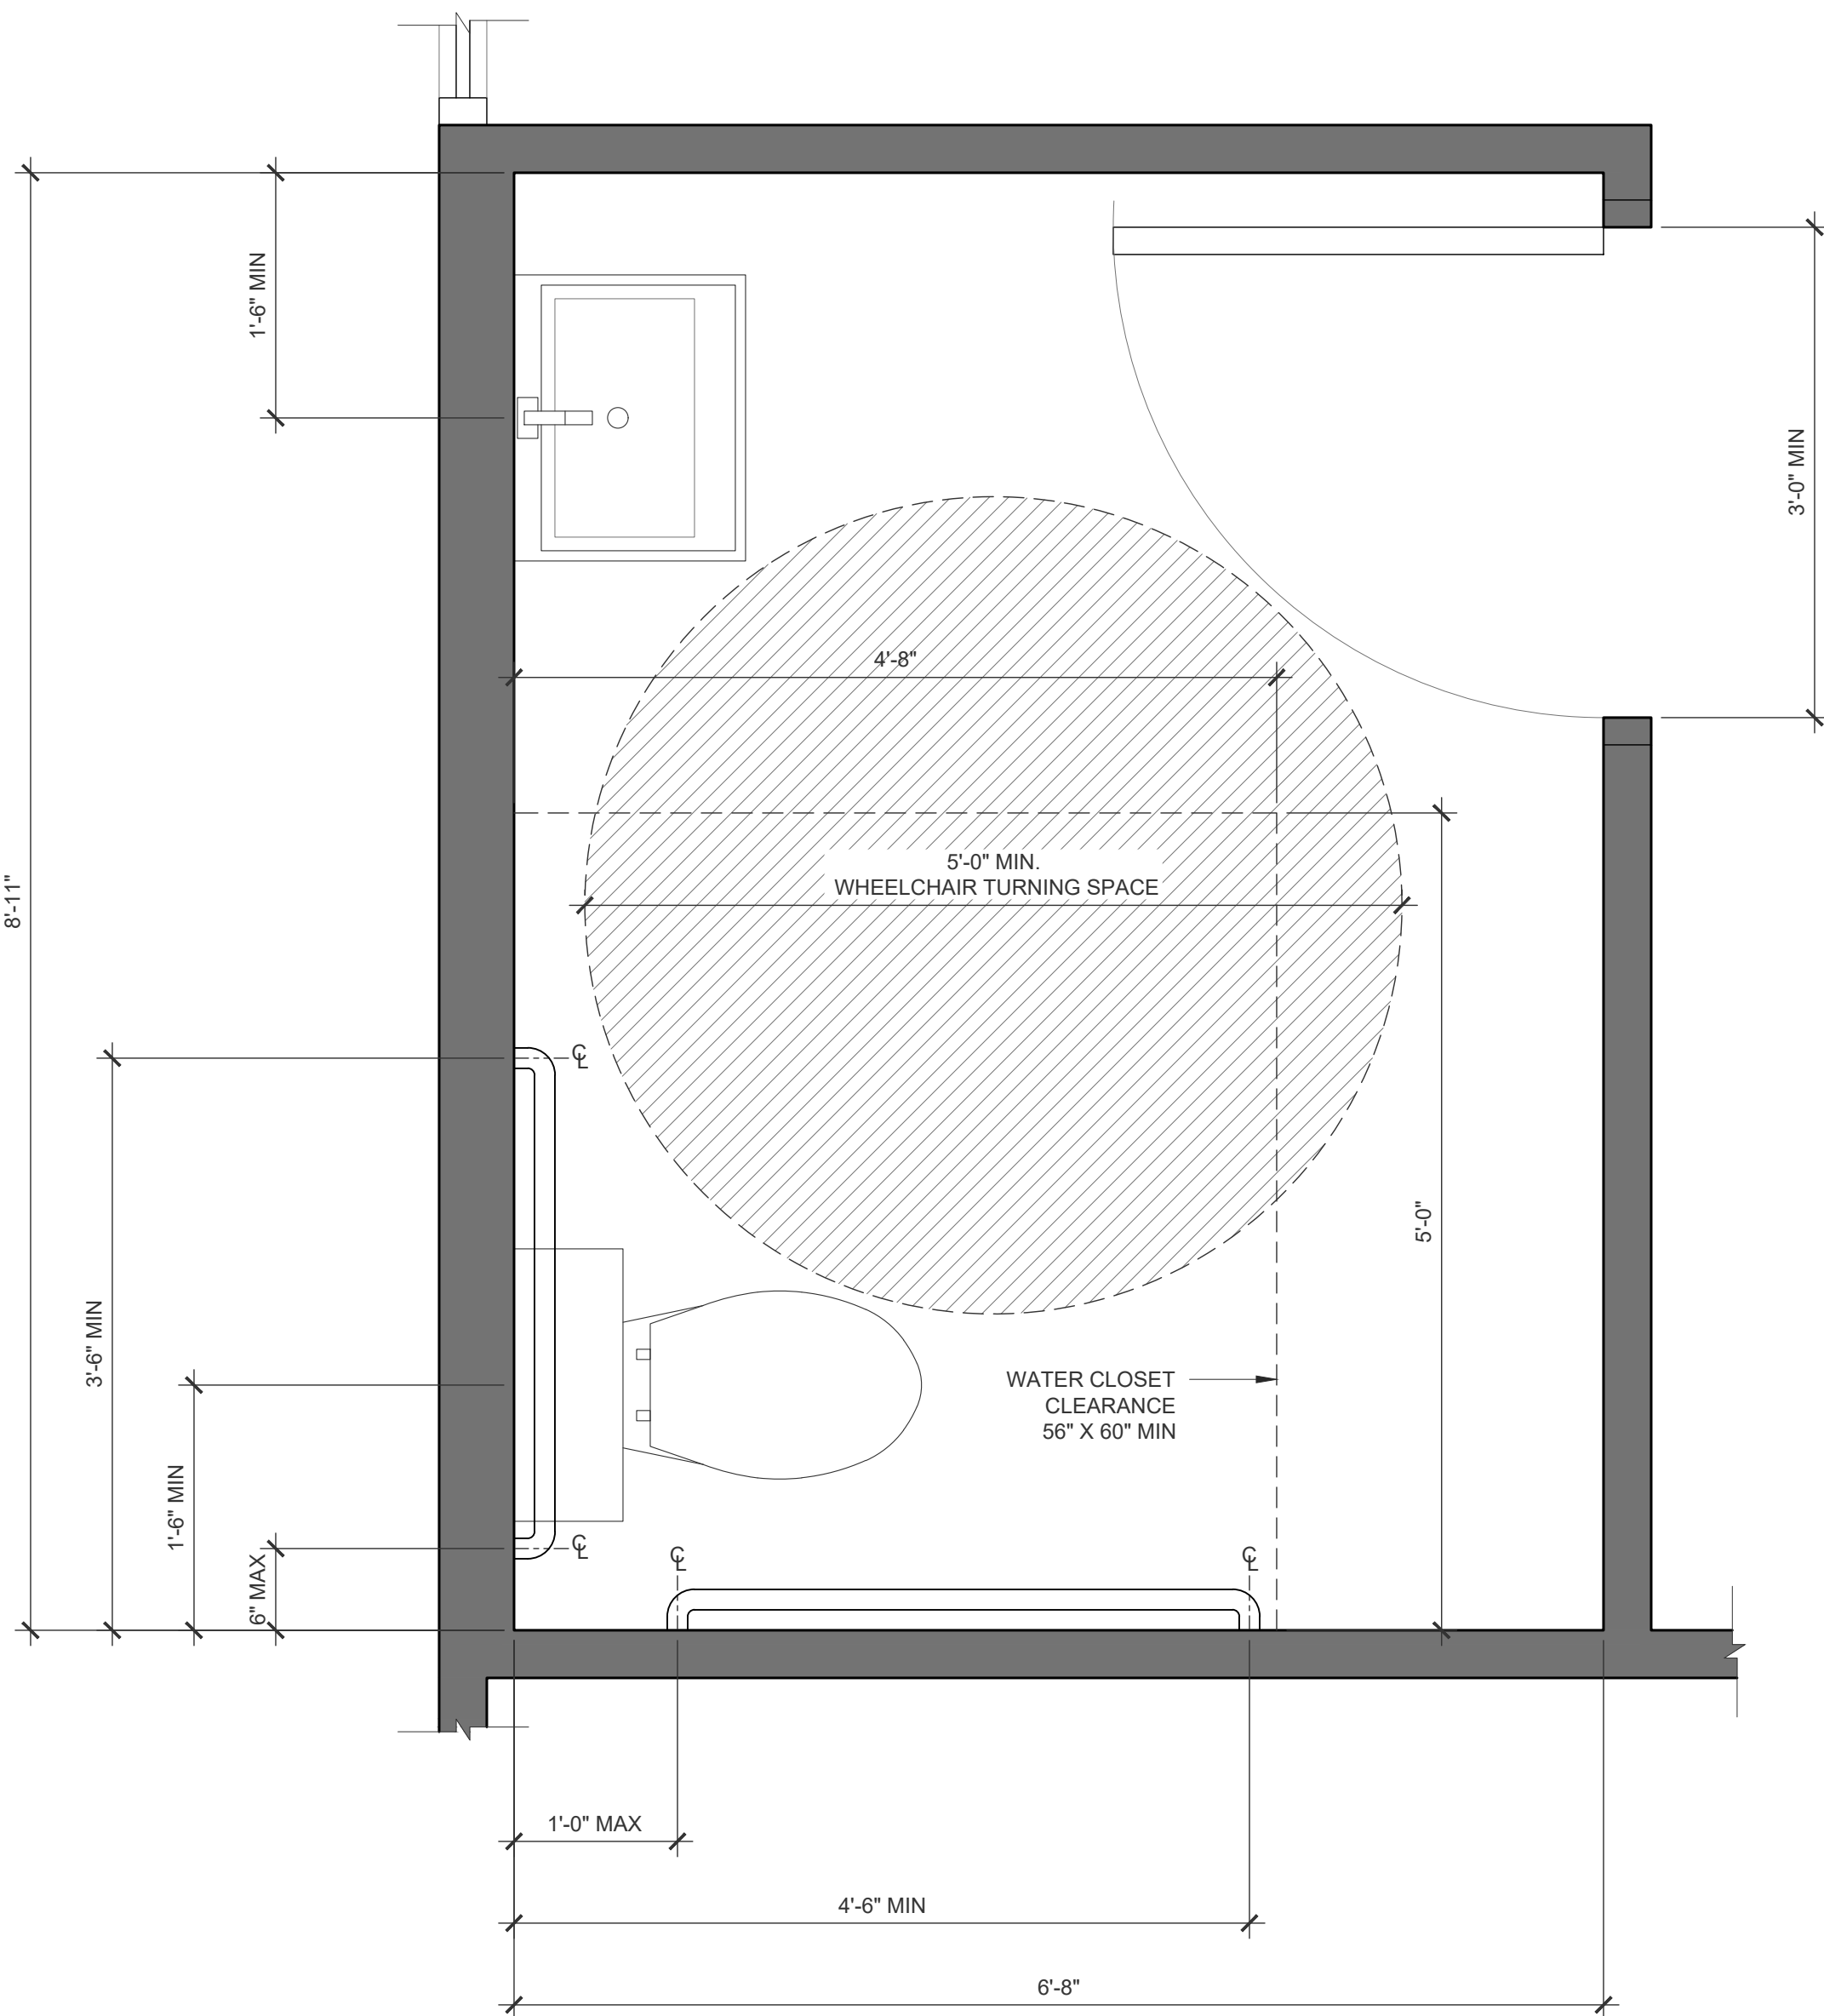


ACCESSIBLE RESTROOM DETAILS B/8

SCALE: 1" = 1'-0"

GENERAL NOTES


1. PROVIDE ANCHOR BOLTS ACCORDING TO STRUCTURAL DRAWINGS
2. PROVIDE HOLDDOWNS AND STRAPS ACCORDING TO STRUCTURAL DRAWINGS
3. VERIFY ALL DIMENSIONS WITH THE FLOOR DIMENSION PLAN
4. BOTTOM OF ALL FOOTINGS ARE TO BE POURED ACCORDING TO LOCAL FROST DEPTH

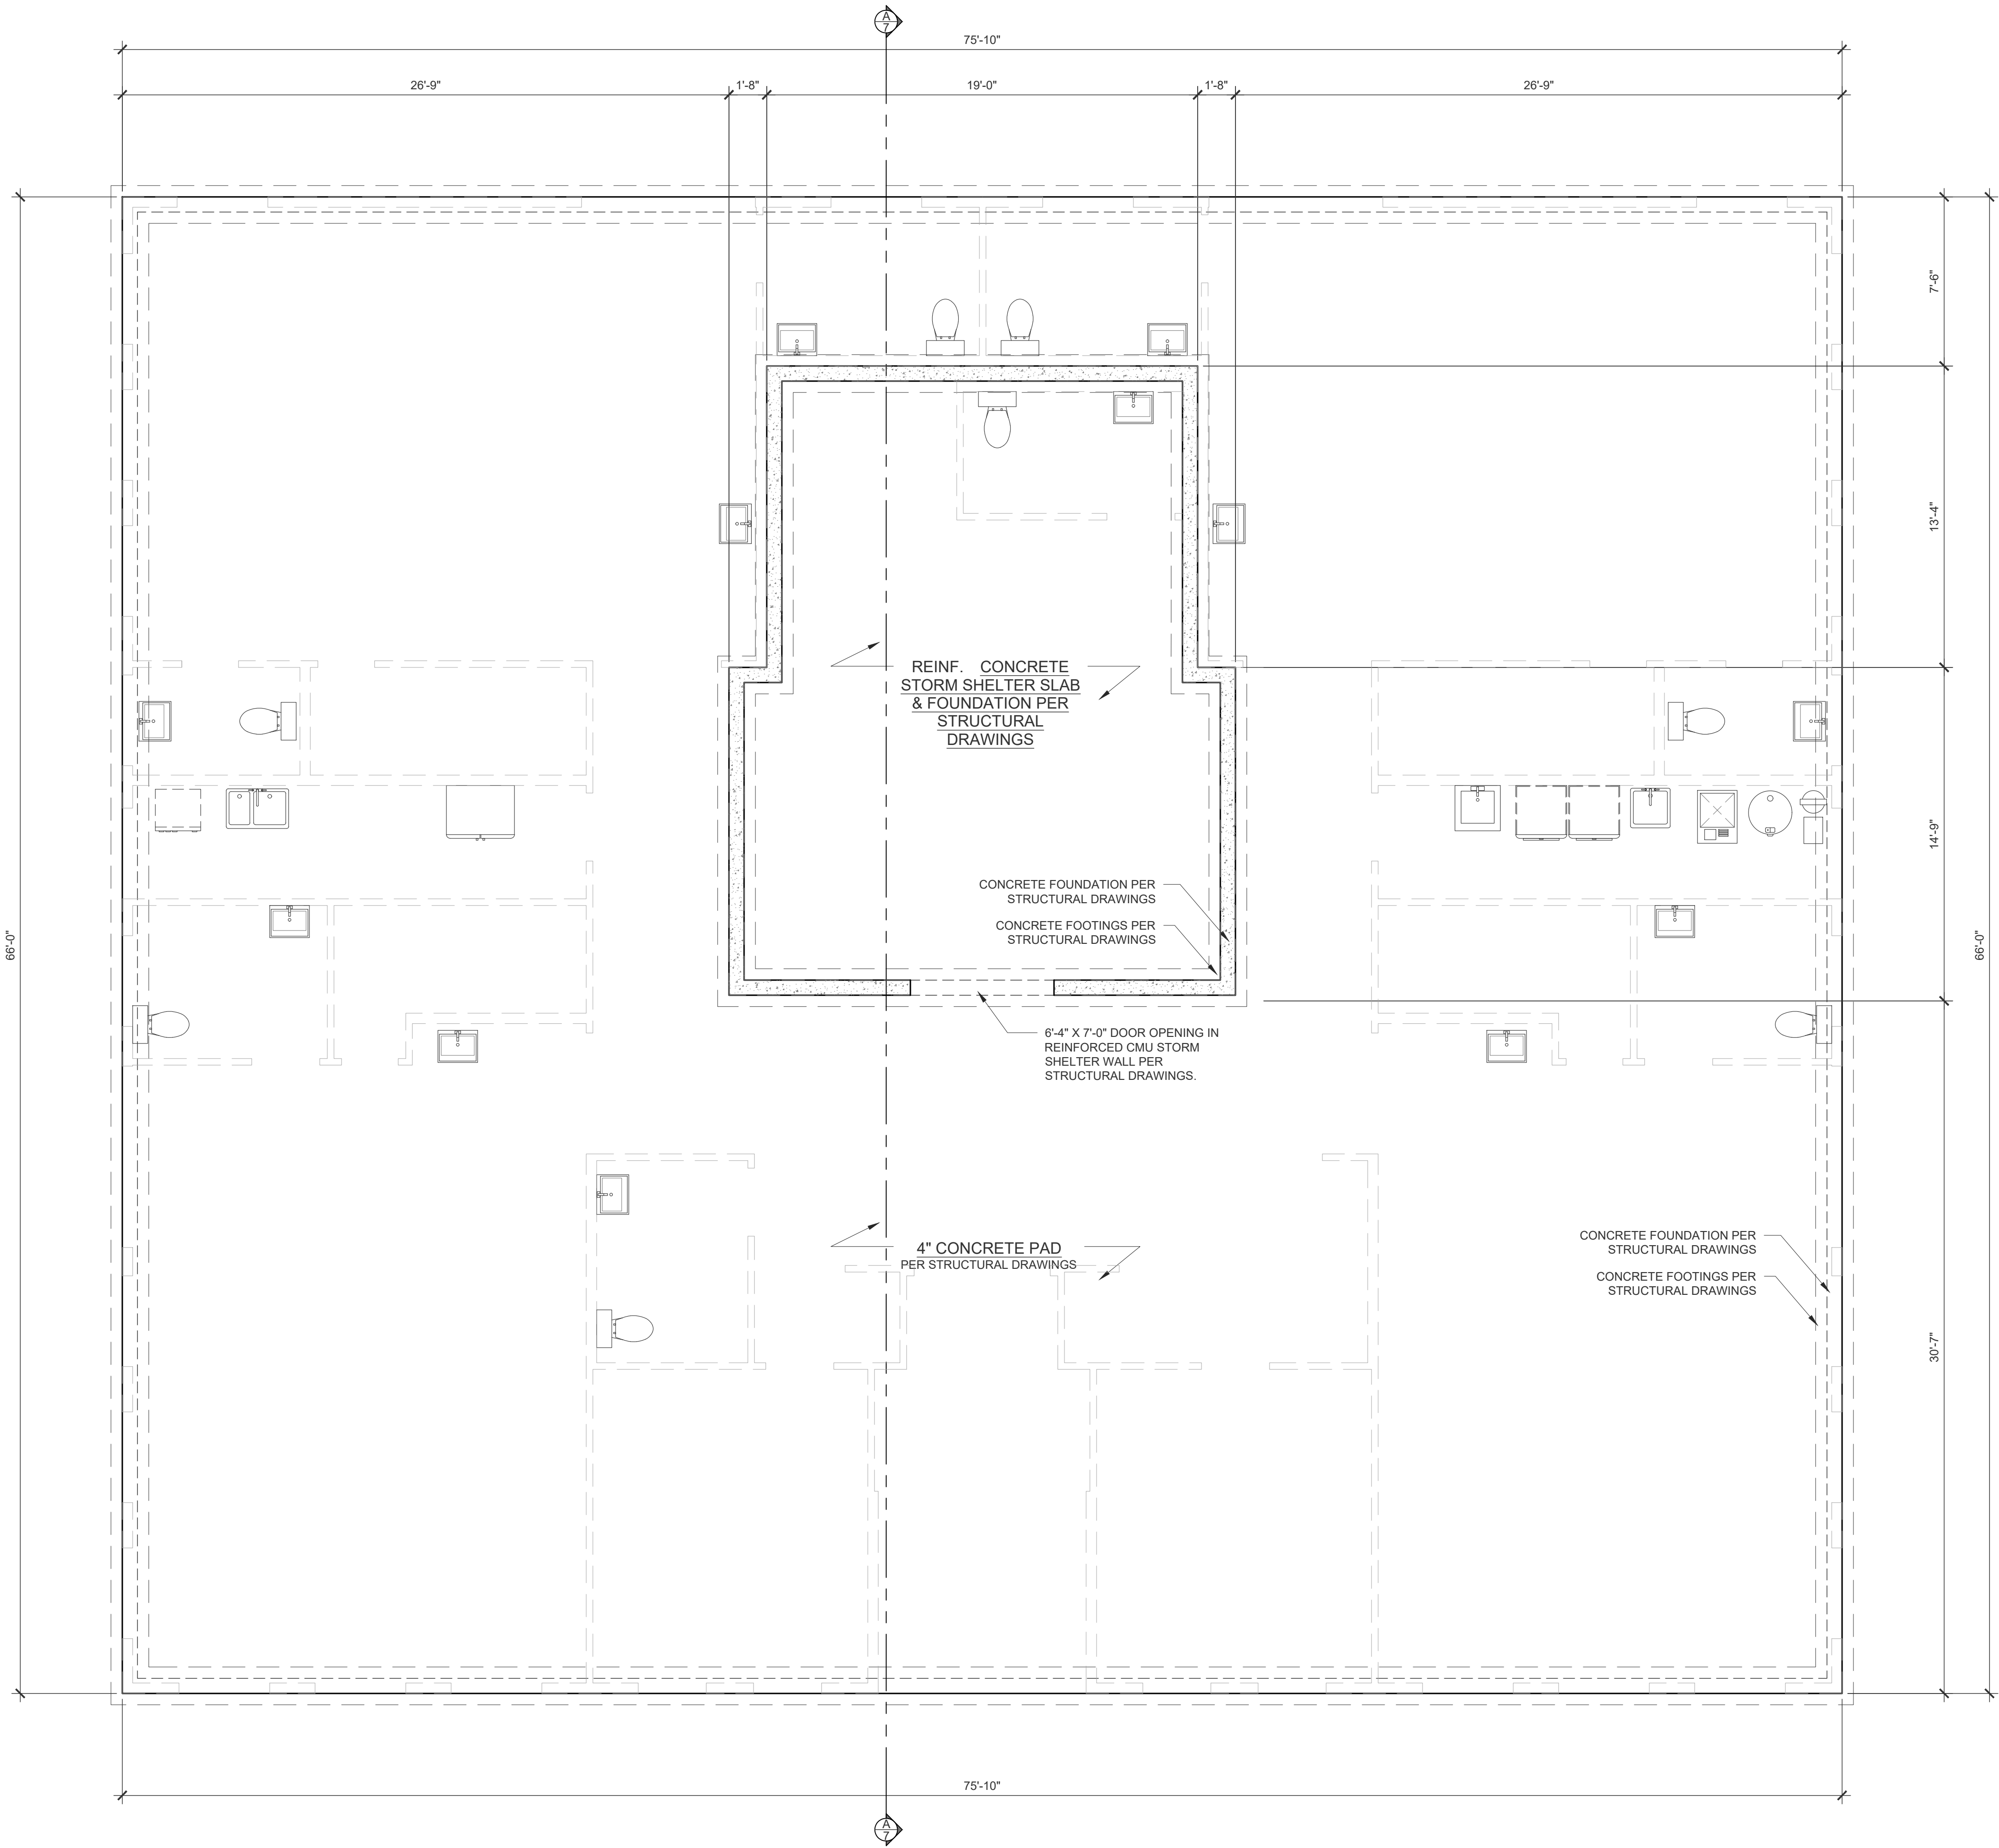

SLAB EDGE PLAN


SCALE: 1/4" = 1'-0"

- 1. 1'-0" TYPICAL ROOF OVERHANG UNLESS NOTED OTHERWISE ON THE PLAN
- 2. 12" TYPICAL HEEL HEIGHT UNLESS NOTED OTHERWISE ON THE PLAN

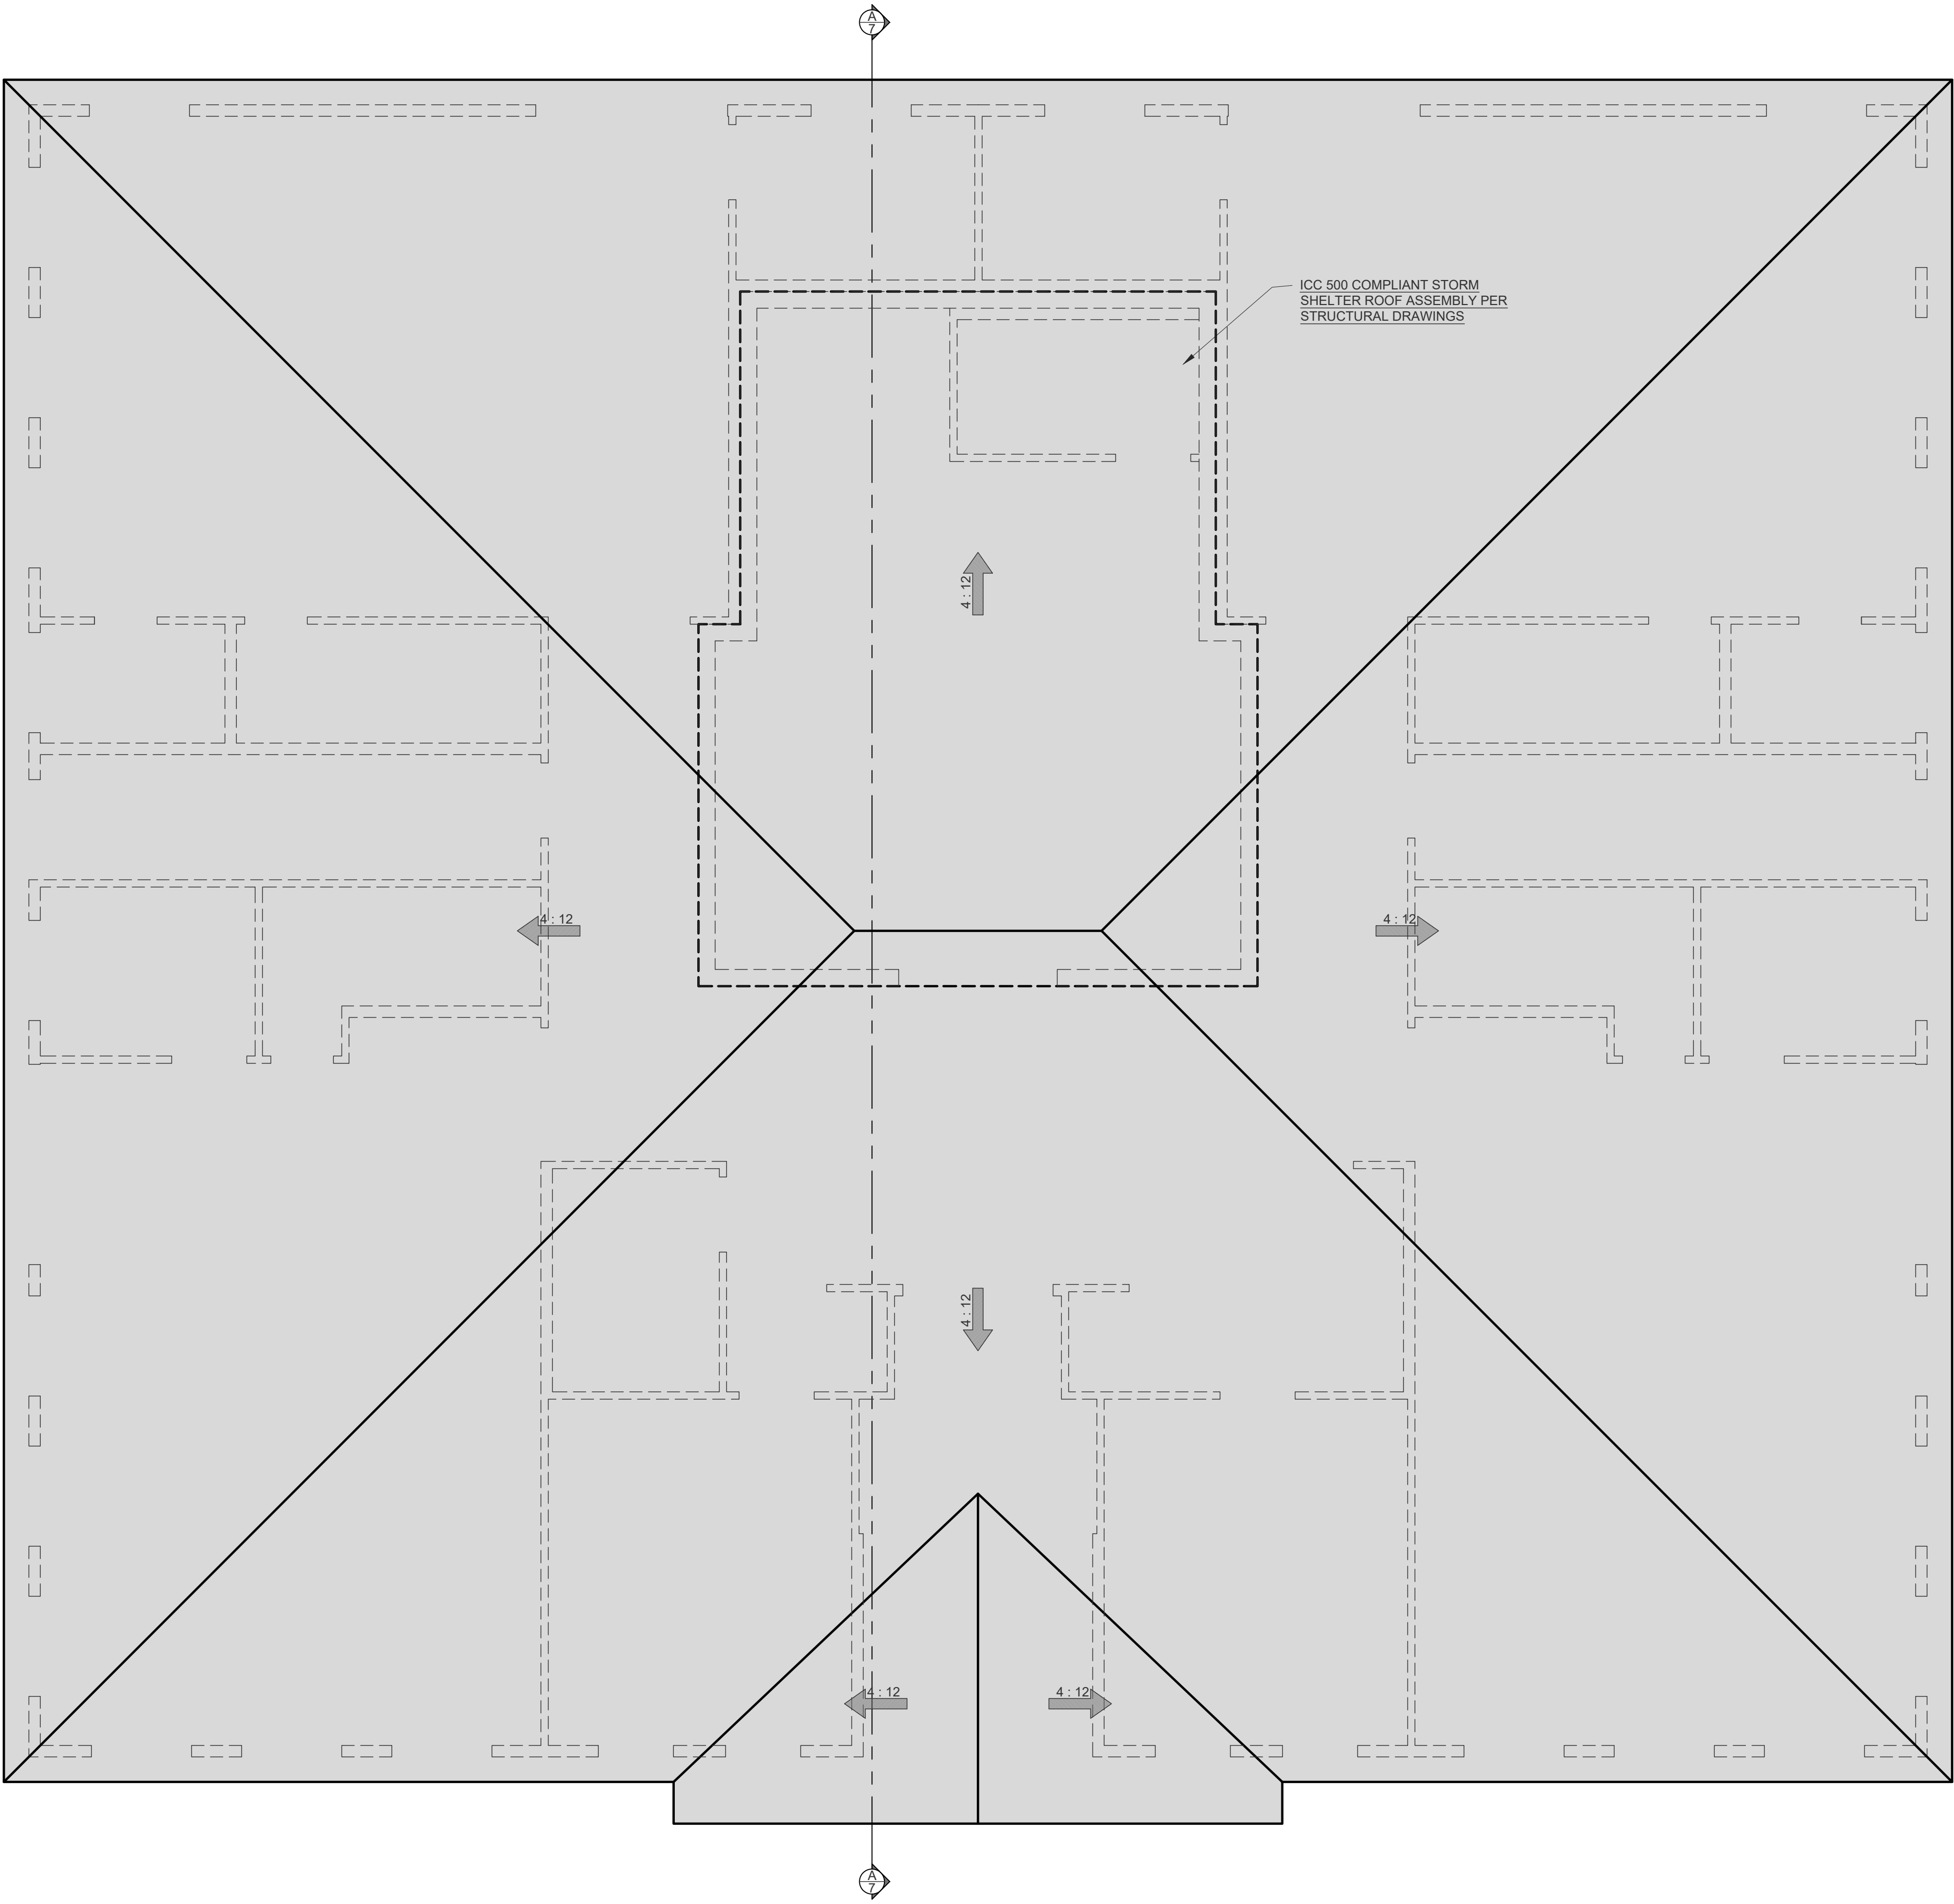

ROOF PLAN

SCALE: 1/4" = 1'-0"

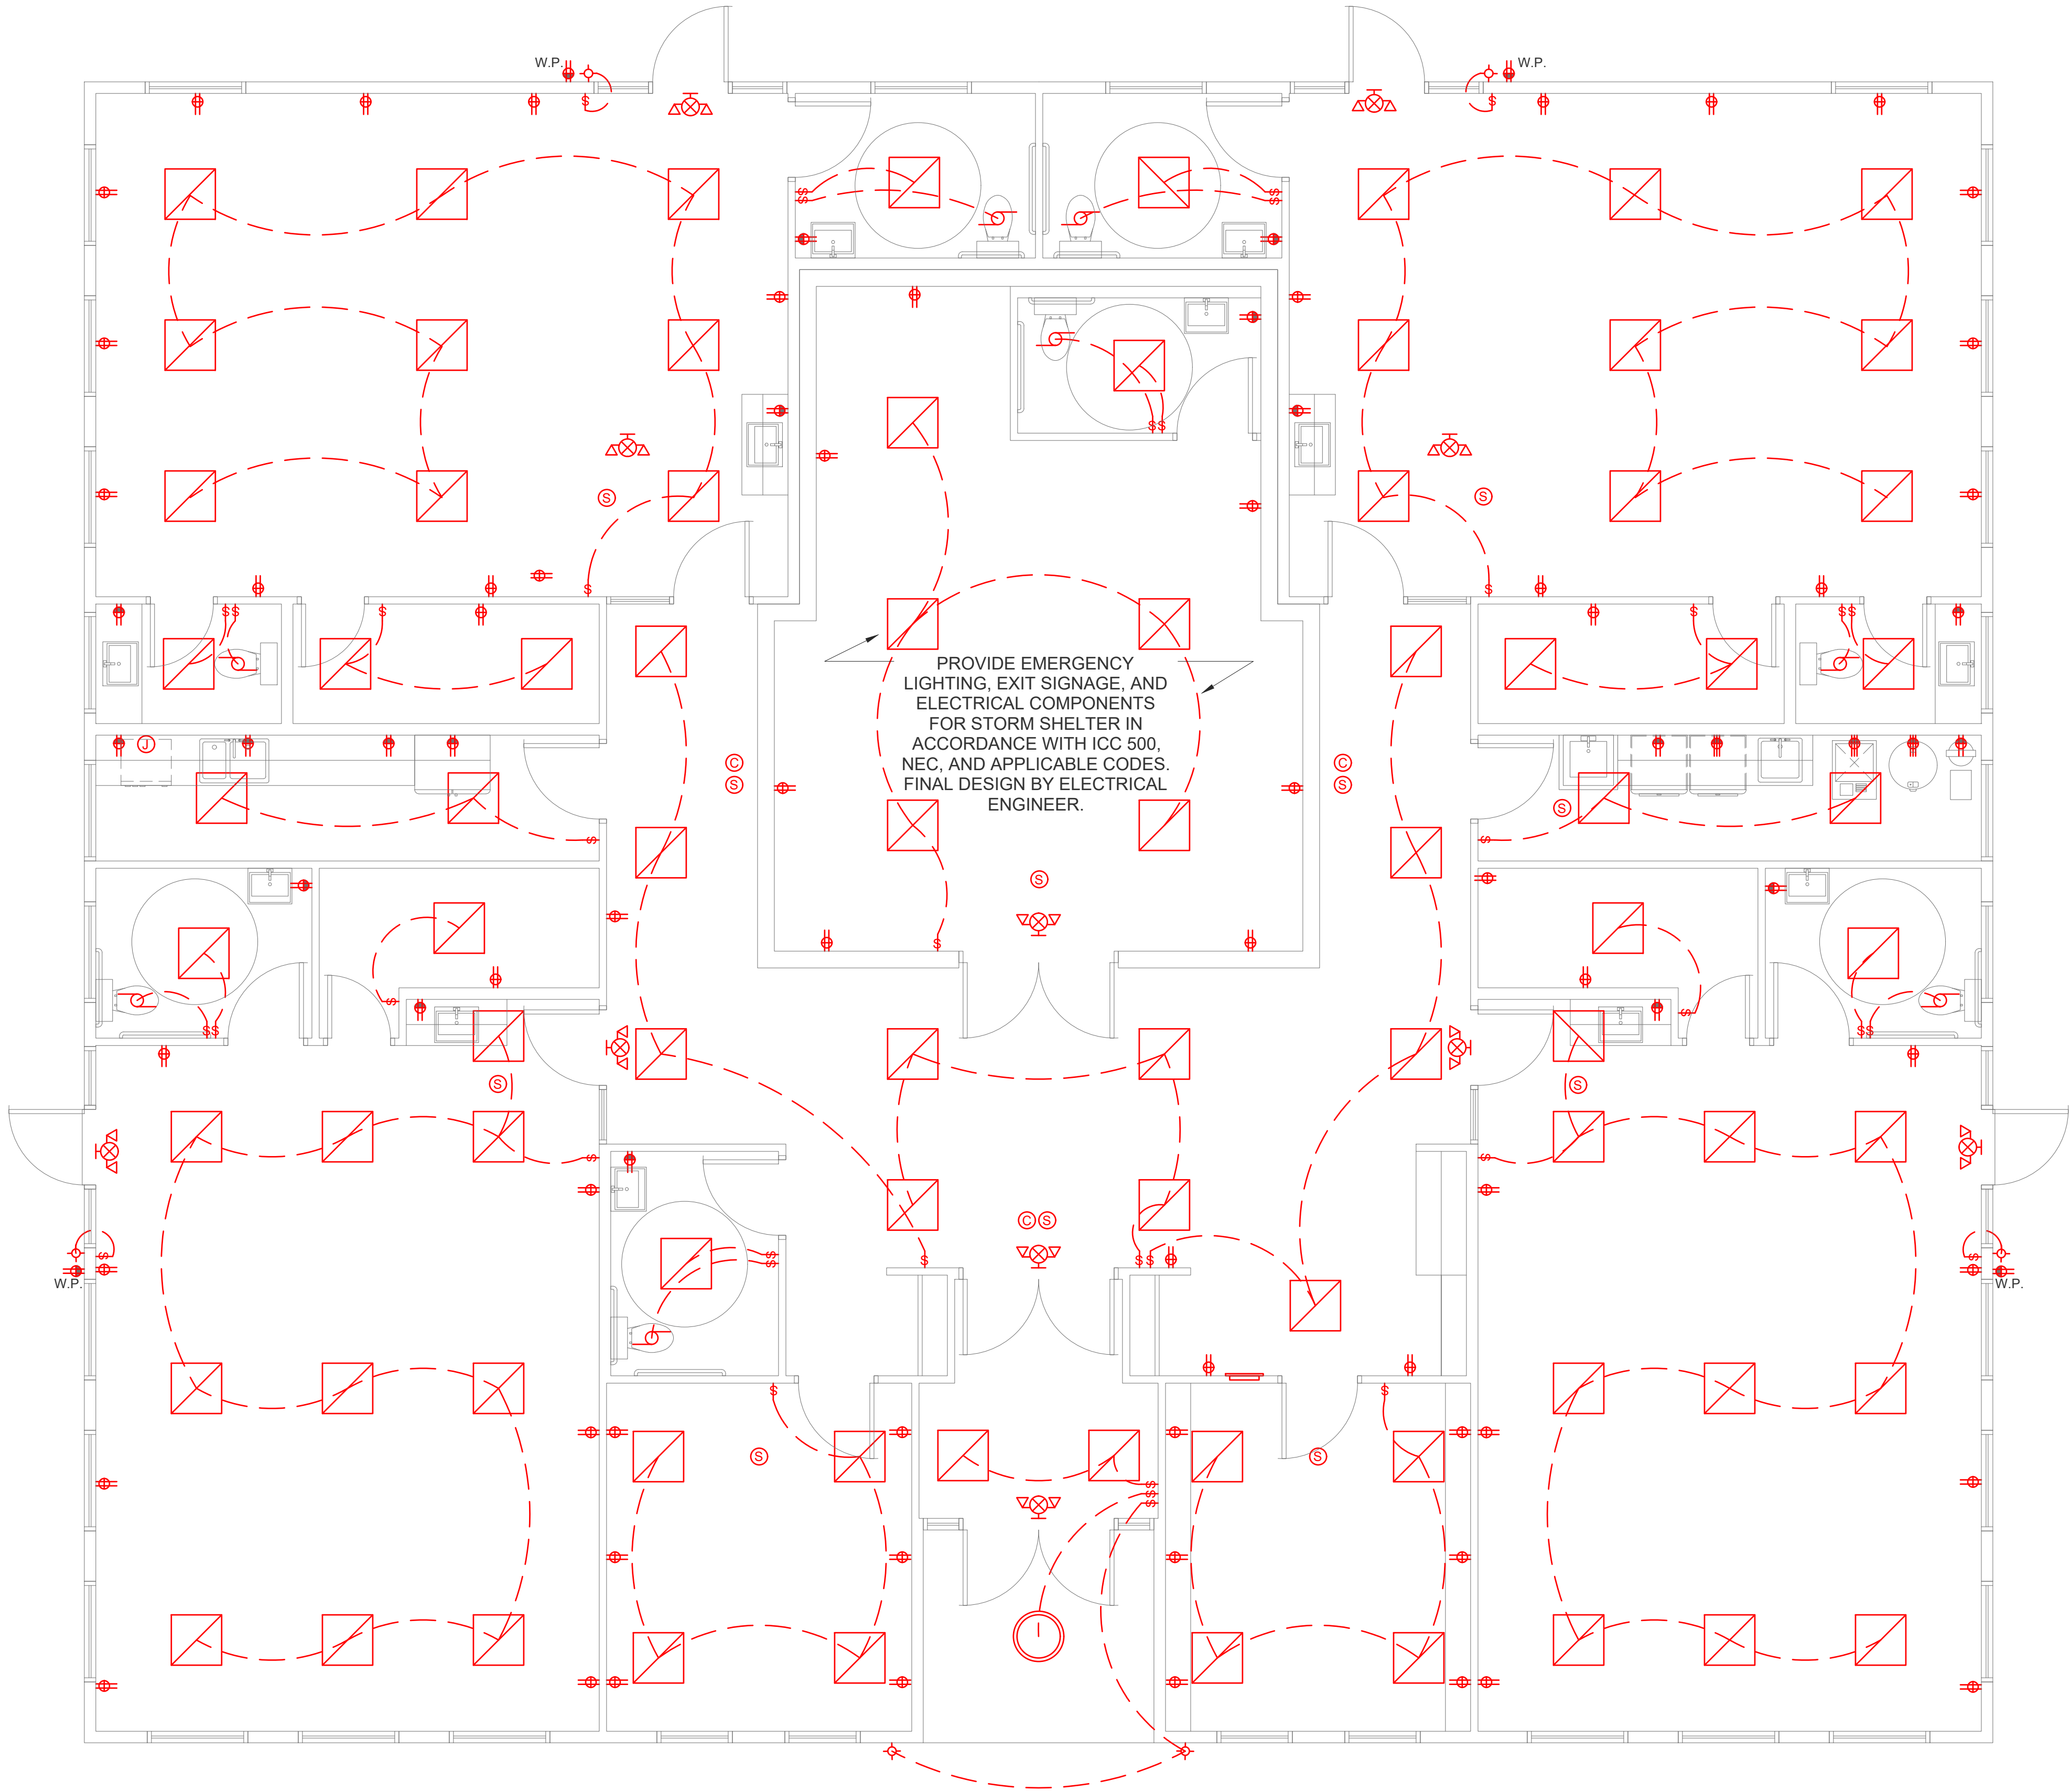

- GENERAL NOTES
- THIS PLAN IS FOR REFERENCE ONLY. ELECTRICAL CONTRACTOR TO DESIGN FULL ELECTRICAL SYSTEM
 - ARC FAULT ALL BEDROOM CIRCUITS
 - INSTALL A DEDICATED GFI BREAKER FOR DISHWASHER


ELECTRICAL LEGEND

	POWER METER
	PANEL BOARD
	EXHAUST FAN
	CEILING FAN
	LIGHT FIXTURE
	RECESSED LIGHT FIXTURE
	PENDANT LIGHT FIXTURE
	VANITY LIGHT FIXTURE
	DUPLEX OUTLET
	GFCI DUPLEX OUTLET
	220v OUTLET
	SWITCH
	THREE-WAY SWITCH
	FOUR-WAY SWITCH
	JUNCTION BOX
	SMOKE DETECTOR
	CARBON DETECTOR
	FUSE DISCONNECT
	2'x2' LED LIGHT
	CIRCLE LED LIGHT

ELECTRICAL PLAN

SCALE: 1/4" = 1'-0"


1. THIS PLAN IS FOR REFERENCE ONLY. PLUMBING CONTRACTOR TO DESIGN FULL PLUMBING SYSTEM

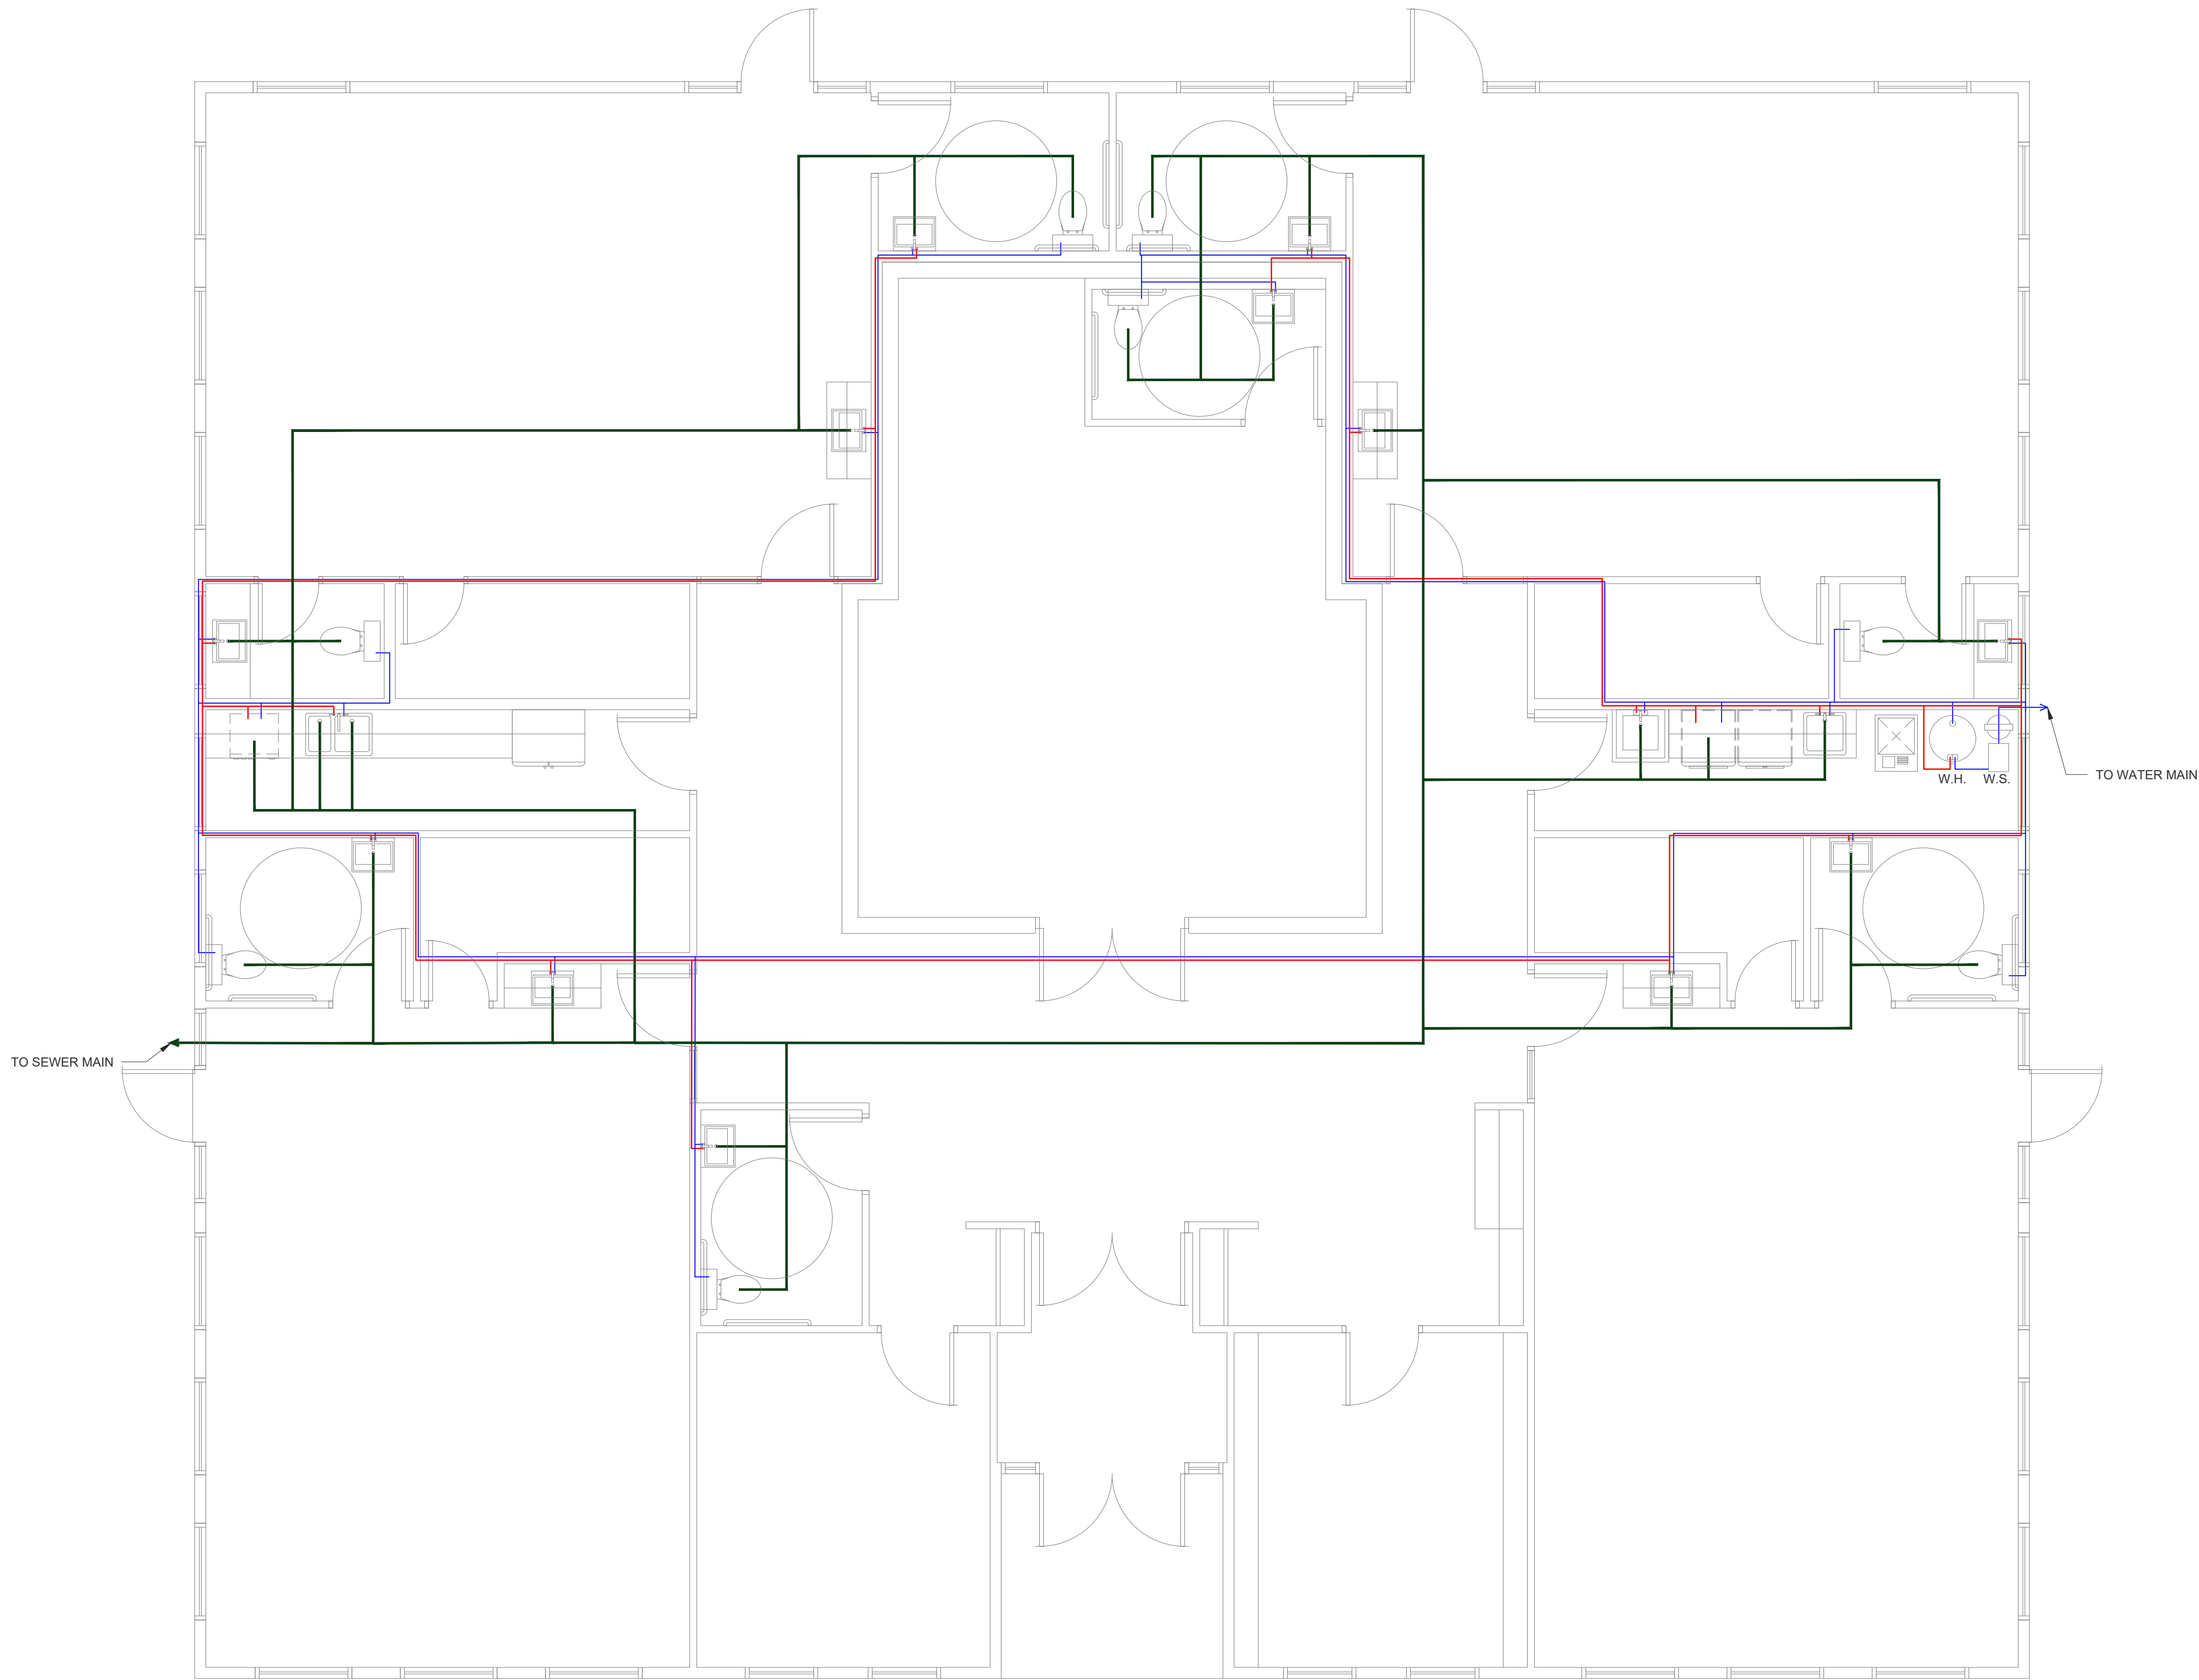


1. THIS PLAN IS FOR REFERENCE ONLY. MECHANICAL CONTRACTOR TO DESIGN FULL MECHANICAL SYSTEM

LEGEND

- EXHAUST FAN
- HVAC FAN
- HVAC UNIT

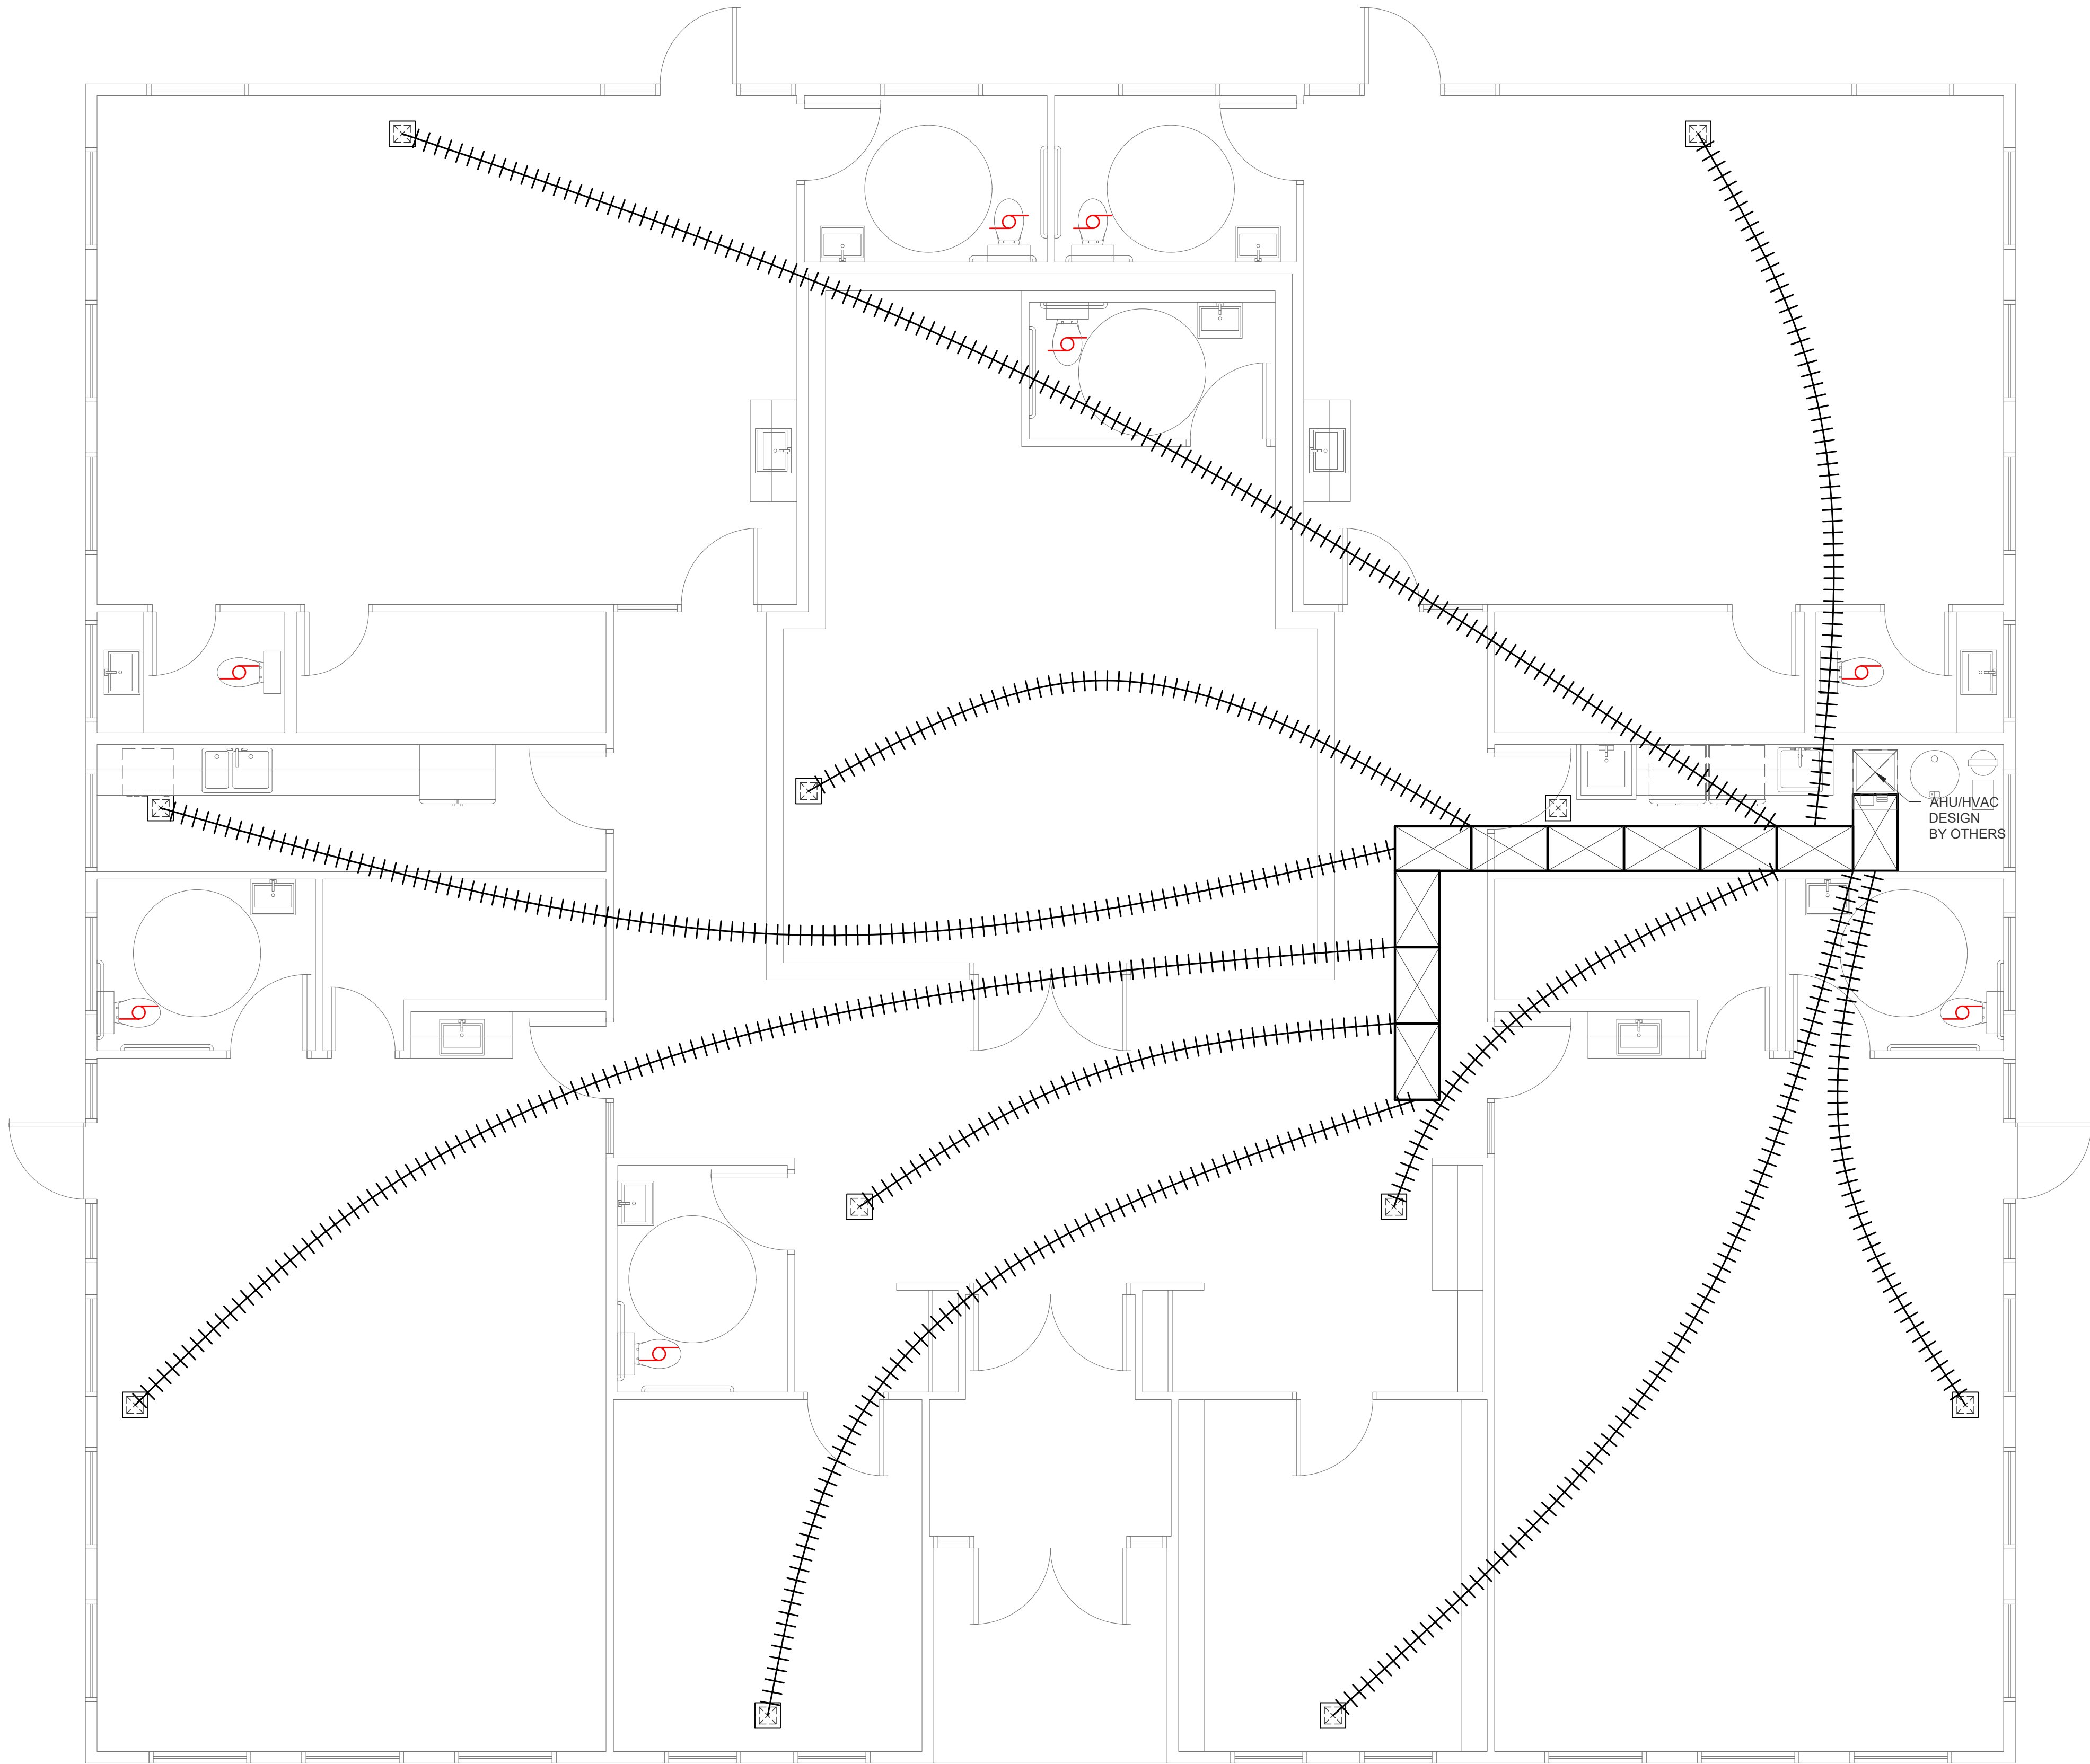

1. THIS PLAN IS FOR LIFE SAFETY REFERENCE ONLY. FIRE PROTECTION AND STORM SHELTER SYSTEMS TO BE DESIGNED AND INSTALLED PER CODE BY OTHERS.

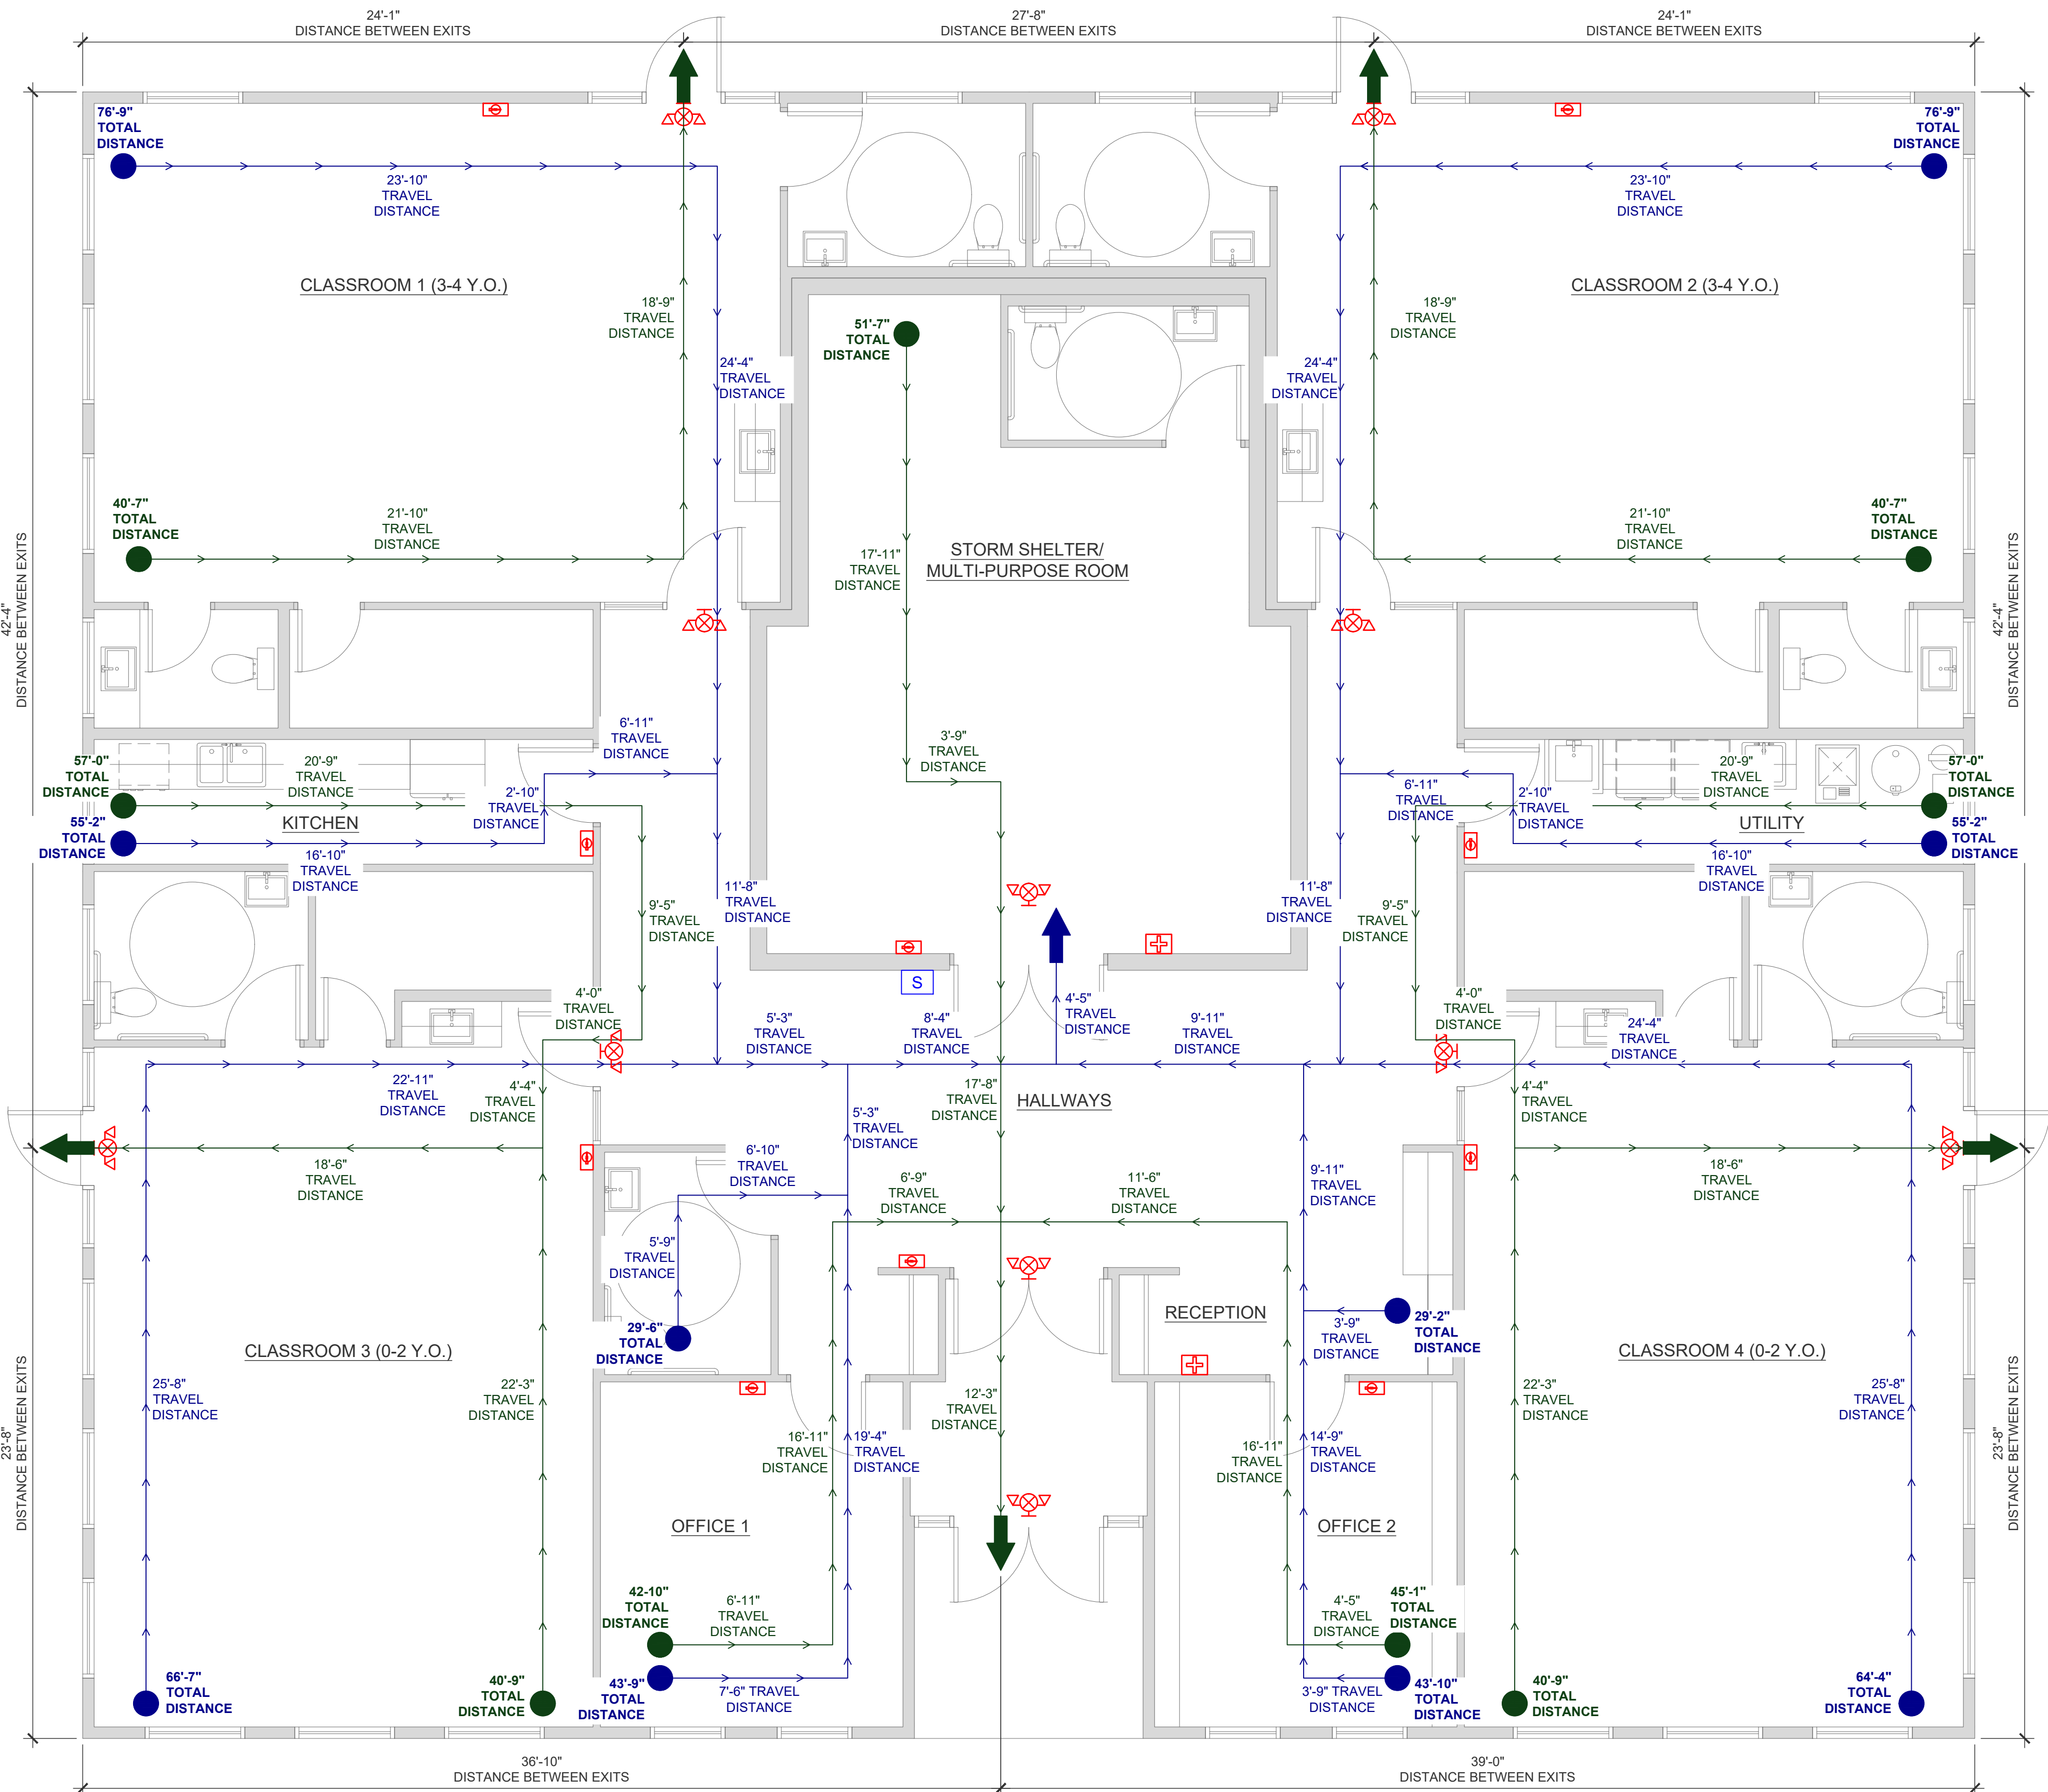

EGRESS COMPONENT SCHEDULE:

EGRESS COMPONENT	OCCUPANT LOAD SERVED	MINIMUM COMPONENT WIDTH	MINIMUM CALCULATED WIDTH	MINIMUM REQUIRED WIDTH	MINIMUM PROVIDED WIDTH
DOOR	166	32" IBC 1010.1.1	$166 \times 0.20 = 33.2"$	36"	36"
COORIDOR	166	44" (>50 O.L.) IBC 1020.2	$166 \times 0.20 = 33.2"$	44"	44"
aisle	166	36" IBC 1018.3	$166 \times 0.20 = 33.2"$	36"	36"

OCCUPANCY LOAD:

ROOM	AREA (SQ. FT.)	FACTOR	TOTAL OCCUPANTS
CLASSROOM 1	761	32 SF / CHILD	23
CLASSROOM 2	761	32 SF / CHILD	23
CLASSROOM 3	722	32 SF / CHILD	22
CLASSROOM 4	722	32 SF / CHILD	22
STORM SHELTER	588	5 SF / OCC.	118
KITCHEN	109	200 SF / OCC.	1
UTILITY	109	300 SF / OCC.	1
HALLWAY	413	15 SF / OCC.	28
RECEPTION	73	100 SF / OCC.	1
OFFICE 1	211	150 SF / OCC.	2
OFFICE 2	241	ACTUAL SEATING	6

- CLASSROOM OCCUPANT LOAD BASED ON ALABAMA DHR MIN. INDOOR ACTIVITY AREA OF 32 SF PER CHILD.
- NON-CLASSROOM AREAS BASED ON IBC OCCUPANT LOAD FACTORS. FINAL ENROLLMENT, STAFFING, AND OCCUPANCY TO BE VERIFIED BY OWNER / AHJ.

LEGEND

- STORM SHELTER TRAVEL PATH
- FIRE EXIT TRAVEL PATH
- STORM SHELTER DIRECTION
- FIRE EXIT DIRECTION
- EXIT SIGN W/ BATTERY POWERED EMERGENCY LIGHTS
- STORM SHELTER SIGN
- WALL-MOUNTED PORTABLE
- FIRST-AID KIT W/ SIGN